




STANDARD DRAWINGS FOR
TRANSIT CAMP - REVISED
(architectural)

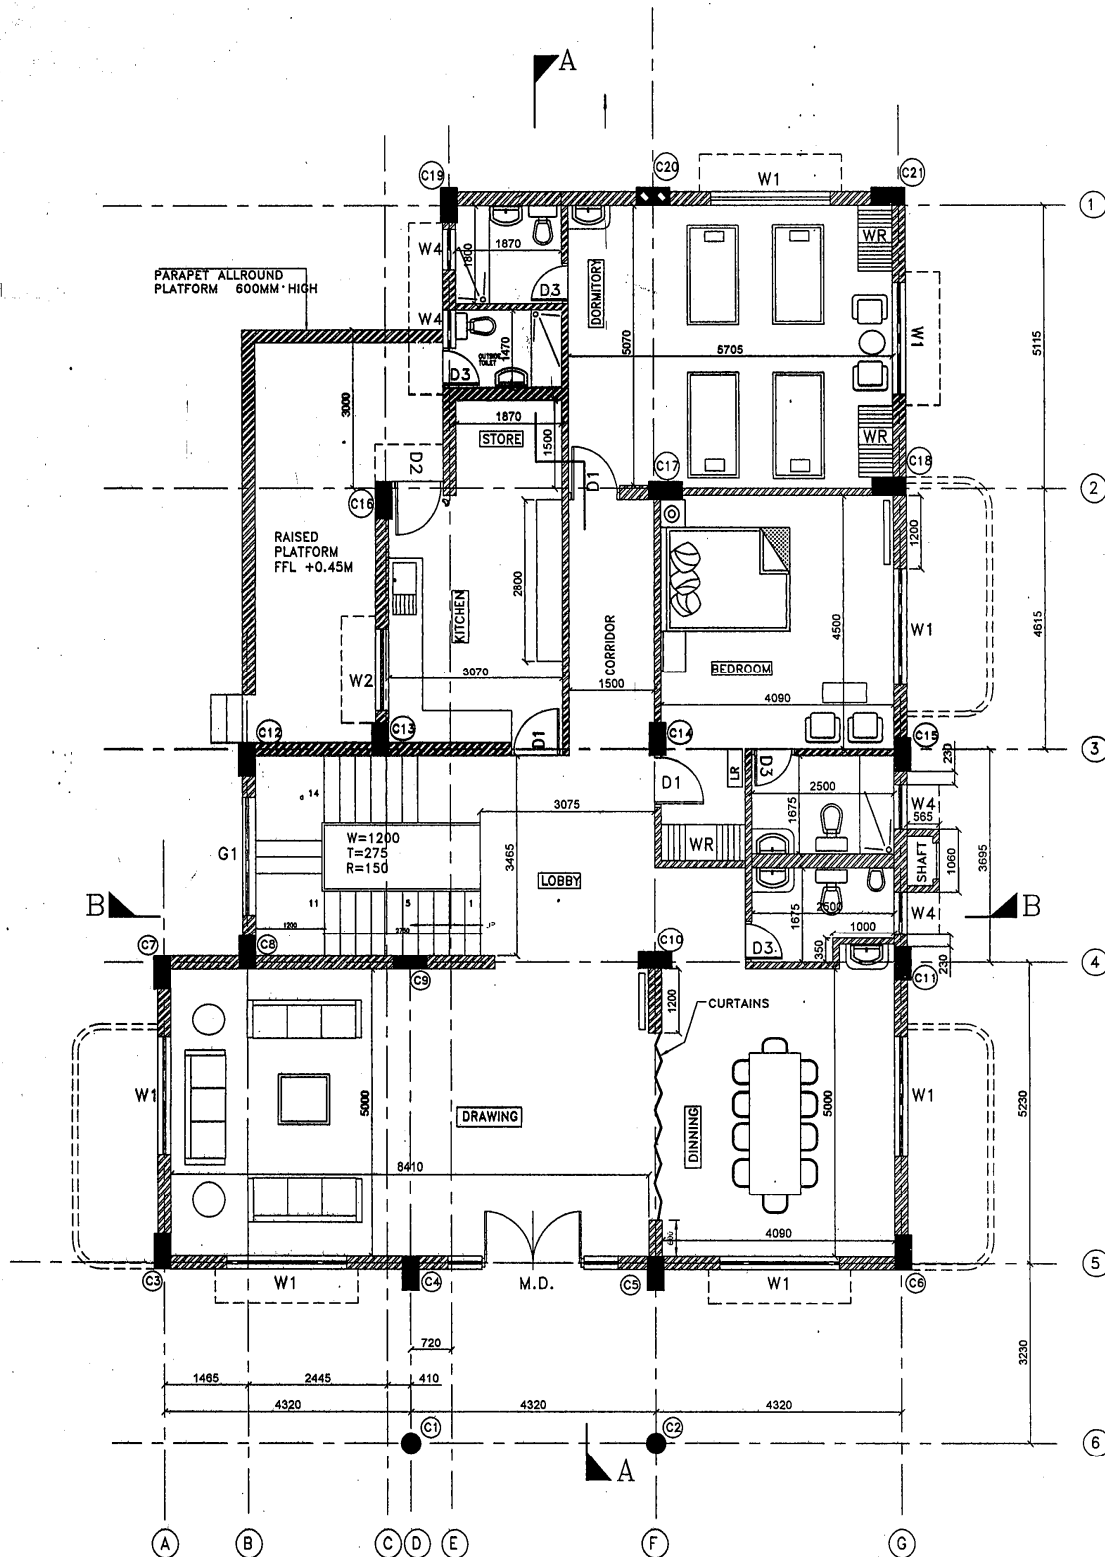

TRANSIT CAMP- GROUND FLOOR

NOTES :

- * WALLS SHOWN THUS ARE 115MM THK. UNLESS & OTHERWISE SPECIFIED
- * WALLS SHOWN THUS ARE 230MM THK.
- * DO NOT MEASURE THESE DRAWING
- * ALL DIMENSIONS SHALL BE CHECKED PRIOR TO EXECUTION OF THE WORK
- * FOR ALL THE R.C.C. WORK REFER R.C.C. DESIGNER'S DRAWING
- * W.R. - WARD ROBE
- * L.R. - LUGGAGE RACK

RELEASED FOR TENDER & CONSTRUCTION.


POWER GRID CORPORATION
OF INDIA LIMITED
(A Government of India Enterprise)



PROJECT :
STANDARD TRANSIT CAMP

TITLE :
GROUND FLOOR PLAN

PLAN REVISED					9/6/14	DATE	SCALE	DRAWING NO.	C/ENGG/STD/TRANSITCAMP/01
REV. - 03	PREP. (CIVIL)	CDE(ENGG- CIVIL)	DGM(ENGG- CIVIL)	GM(ENGG-CIVIL)			NTS		

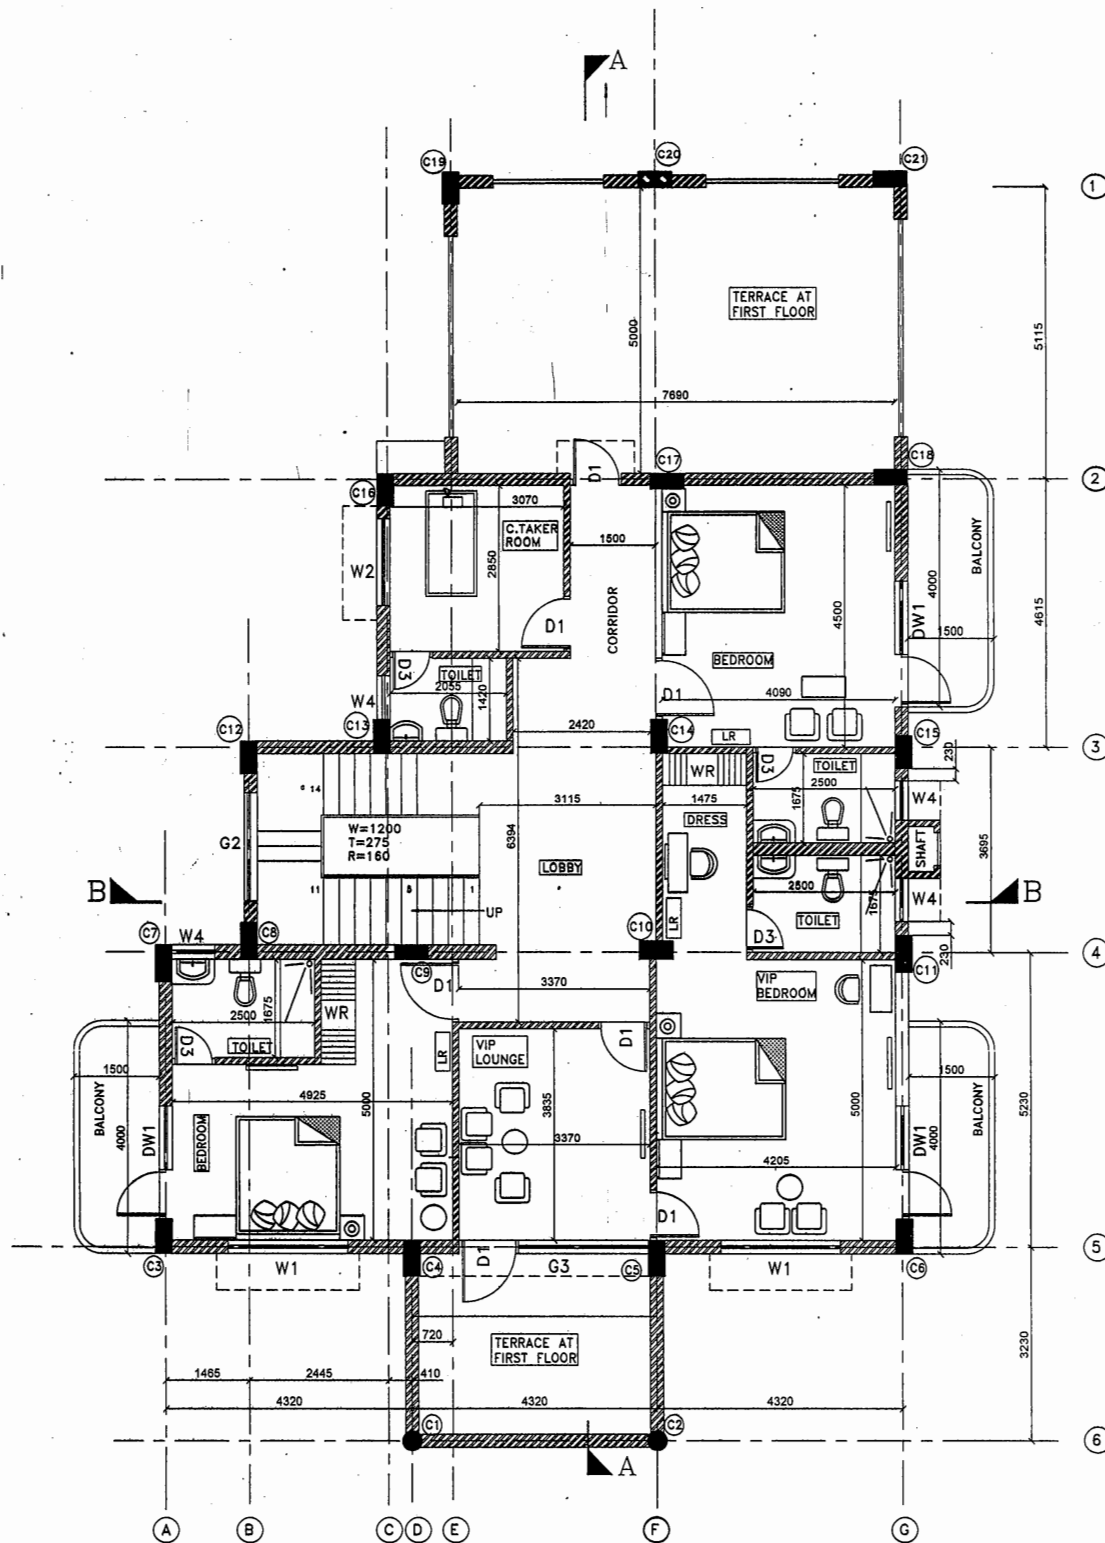

TRANSIT CAMP- FIRST FLOOR

NOTES :

- * WALLS SHOWN THUS ARE 115MM THK. UNLESS & OTHERWISE SPECIFIED
- * WALLS SHOWN THUS ARE 230MM THK.
- * DO NOT MEASURE THESE DRAWING
- * ALL DIMENSIONS SHALL BE CHECKED PRIOR TO EXECUTION OF THE WORK
- * FOR ALL THE R.C.C. WORK REFER R.C.C. DESIGNER'S DRAWING
- * W.R. - WARD ROBE
- * L.R. - LUGGAGE RACK

RELEASED FOR TENDER & CONSTRUCTION.


POWER GRID CORPORATION
OF INDIA LIMITED
(A Government of India Enterprise)




PROJECT :
STANDARD TRANSIT CAMP

TITLE :
FIRST FLOOR PLAN

PLAN REVISED	<i>[Signature]</i>	<i>[Signature]</i>	<i>[Signature]</i>	<i>[Signature]</i>	DATE	SCALE	DRAWING NO.
REV. - 03	PREP. (CIVIL)	CDE(ENGG- CIVIL)	DGM(ENGG- CIVIL)	GM(ENGG-CIVIL)	9/6/14	NTS	C/ENGG/STD/TRANSITCAMP/02

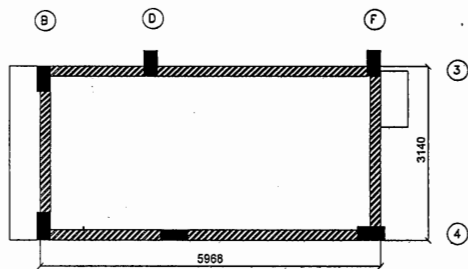

TRANSIT CAMP- MUMTY ROOF

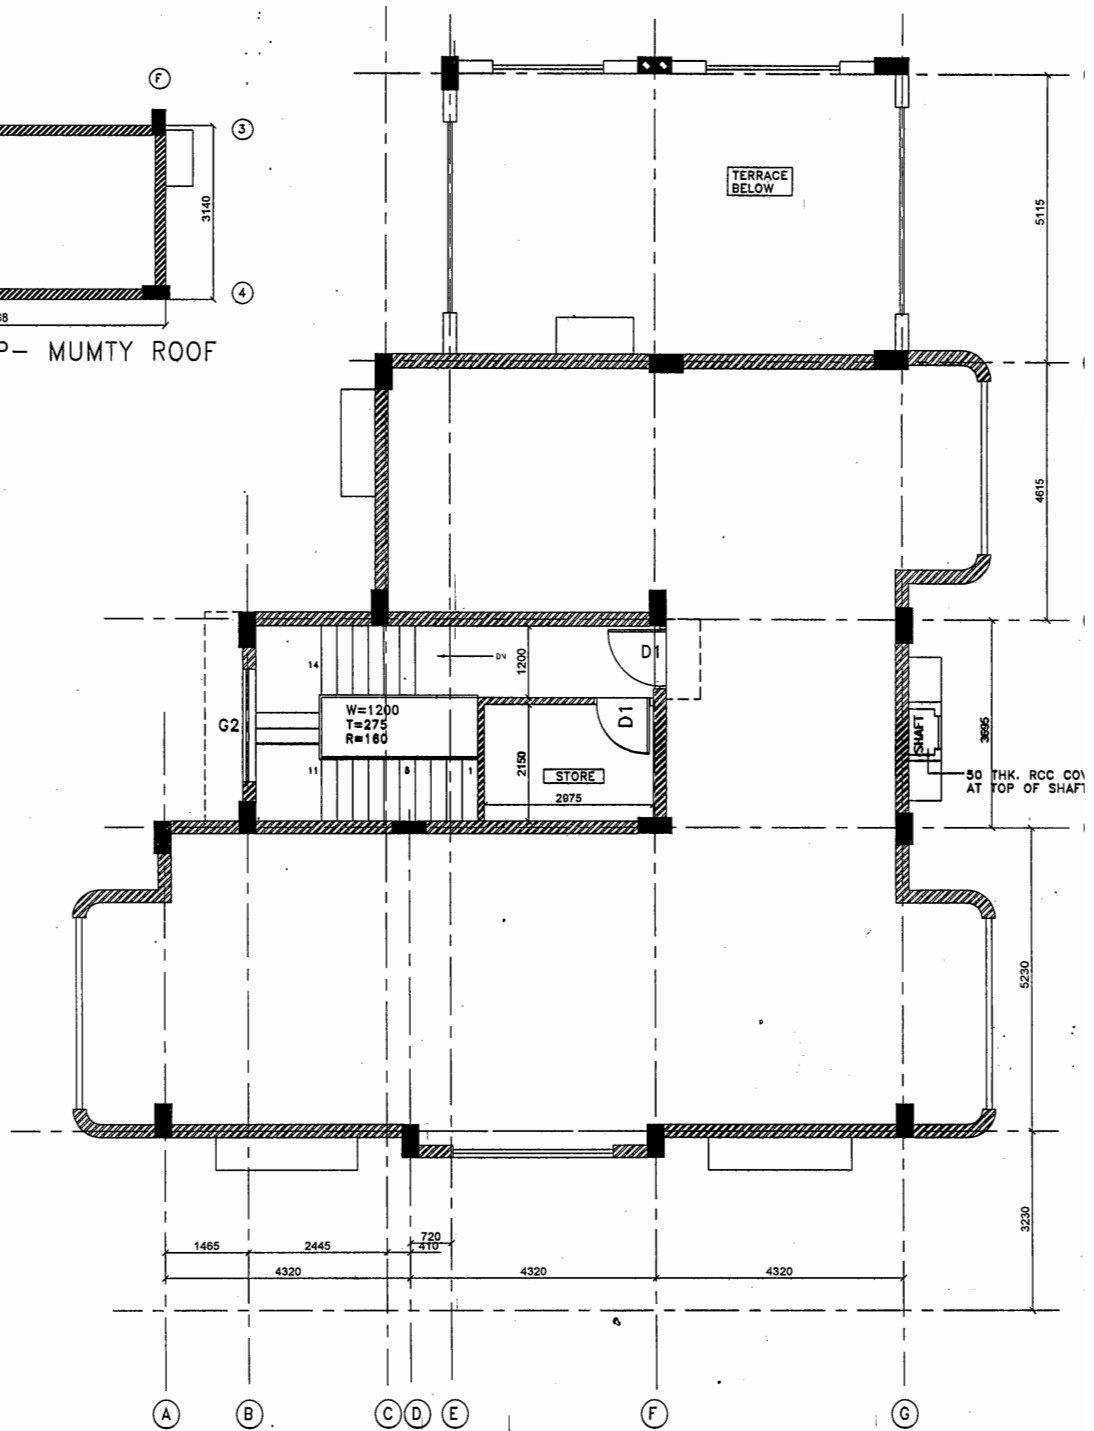

TRANSIT CAMP- TERRACE FLOOR

NOTES :


- * WALLS SHOWN THUS ARE 115MM THK. UNLESS & OTHERWISE SPECIFIED
- * WALLS SHOWN THUS ARE 230MM THK.
- * DO NOT MEASURE THESE DRAWING
- * ALL DIMENSIONS SHALL BE CHECKED PRIOR TO EXECUTION OF THE WORK
- * FOR ALL THE R.C.C. WORK REFER R.C.C. DESIGNER'S DRAWING
- * W.R. - WARD ROBE
- * L.R. - LUGGAGE RACK

RELEASED FOR TENDER & CONSTRUCTION.


POWER GRID CORPORATION
OF INDIA LIMITED
(A Government of India Enterprise)

PROJECT :
STANDARD TRANSIT CAMP


PLAN REVISED					DATE	TITLE :	WORKING DRAWING MUMTY / TERRACE PLAN
REV. - 02	PREP. (CIVIL)	CDE(ENGG- CIVIL)	DGM(ENGG- CIVIL)	GM(ENGG-CIVIL)	9/11/14	SCALE NTS	DRAWING NO. C/ENGG/STD/TRANSITCAMP/03

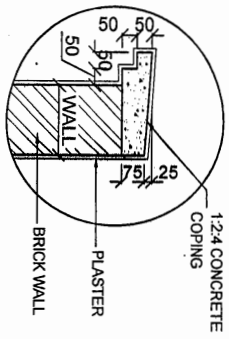

DETAIL - A
TYP.

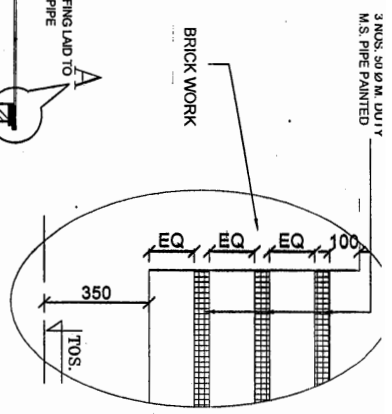

DETAIL - C
TYP.

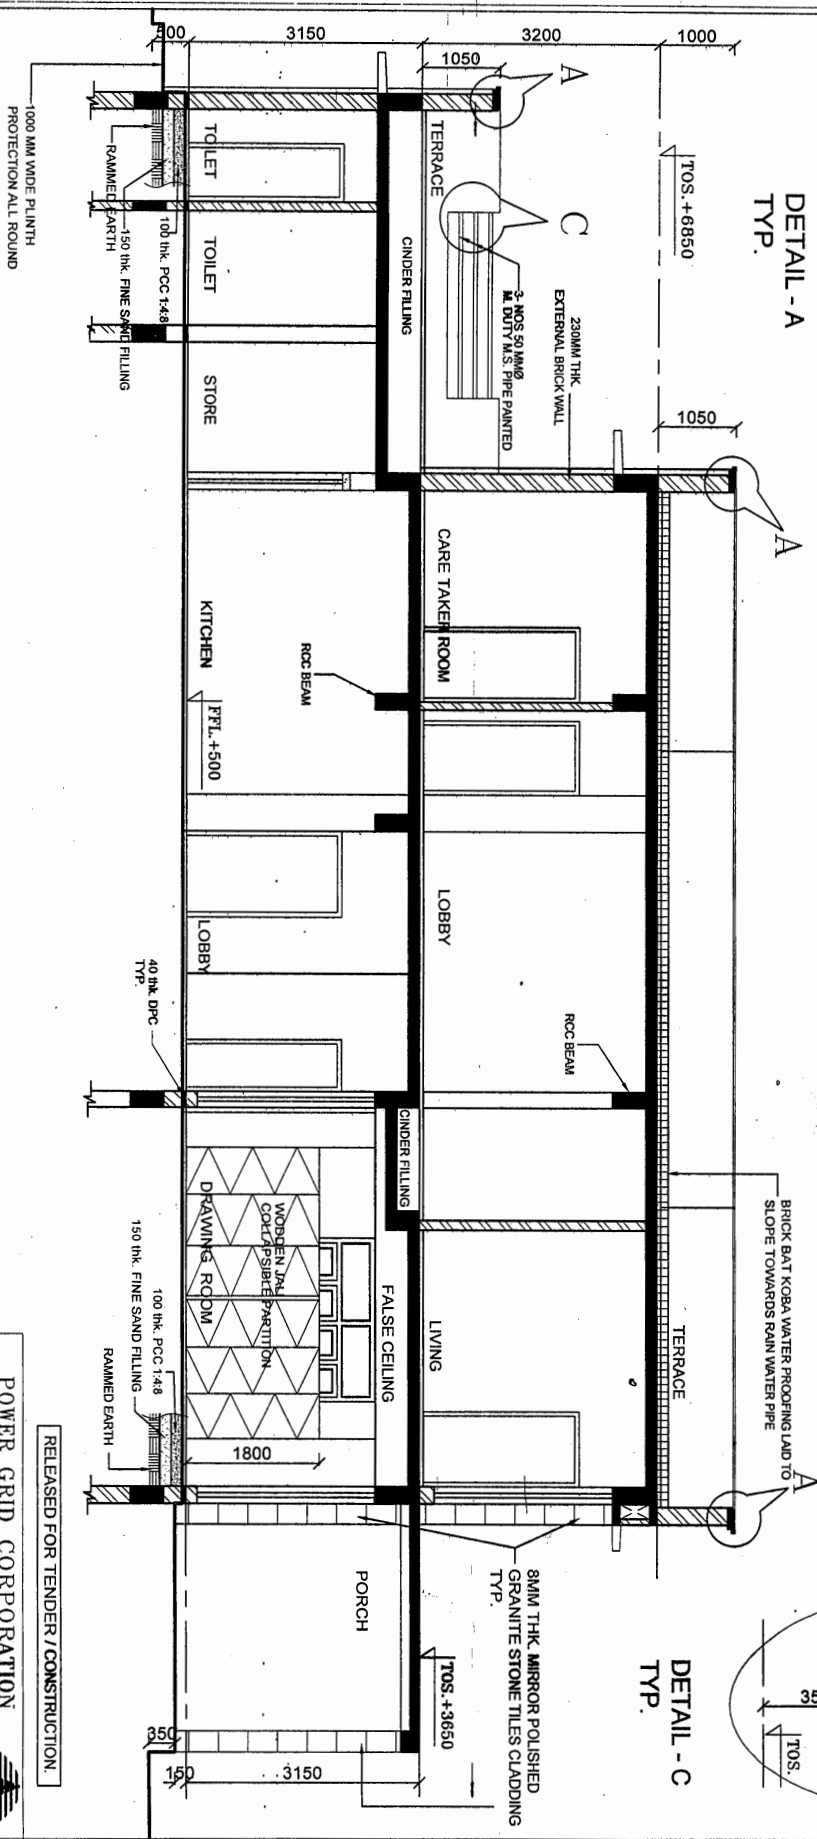

RELEASED FOR TENDER/CONSTRUCTION.


POWER GRID CORPORATION
OF INDIA LIMITED
(A Government of India Enterprise)



PROJECT:
STANDARD TRANSIT CAMP

TITLE:
SECTION A-A

CHANGES AS PER REVISED PLAN	PREP (CIVIL)	CORRENG- (CIVIL)	DOINGENG- (CIVIL)	ENGINEG-CIVIL	DATE	SCALE	DRAWING NO.	REV
REV - 03	1/1/16	1/1/16	1/1/16	1/1/16	1/1/16	1:100	C-ENG-STD-TRANSIT CAMP-04	03


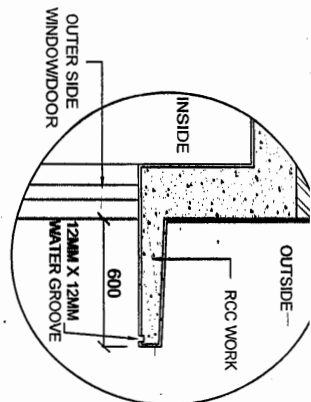


20MM X 6MM
PLASTER GROOVE
TYP.



TITLE: SECTION B-B

CHANGES AS PER REVISED PLAN	PREP. (CIVIL)	CODE/ENG-CIVIL	DOM/ENG-CIVIL	GM/ENG-CIVIL	DATE	TITLE:	SCALE	DRAWING NO.	REV
REV. - 01	publi	g Sharma	Dr m	20/11/16	20/11/16	SECTION B-B	1/1	C-ENG-STD-TRANSIT CAMP-04a	R-01

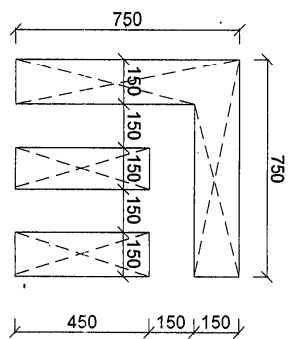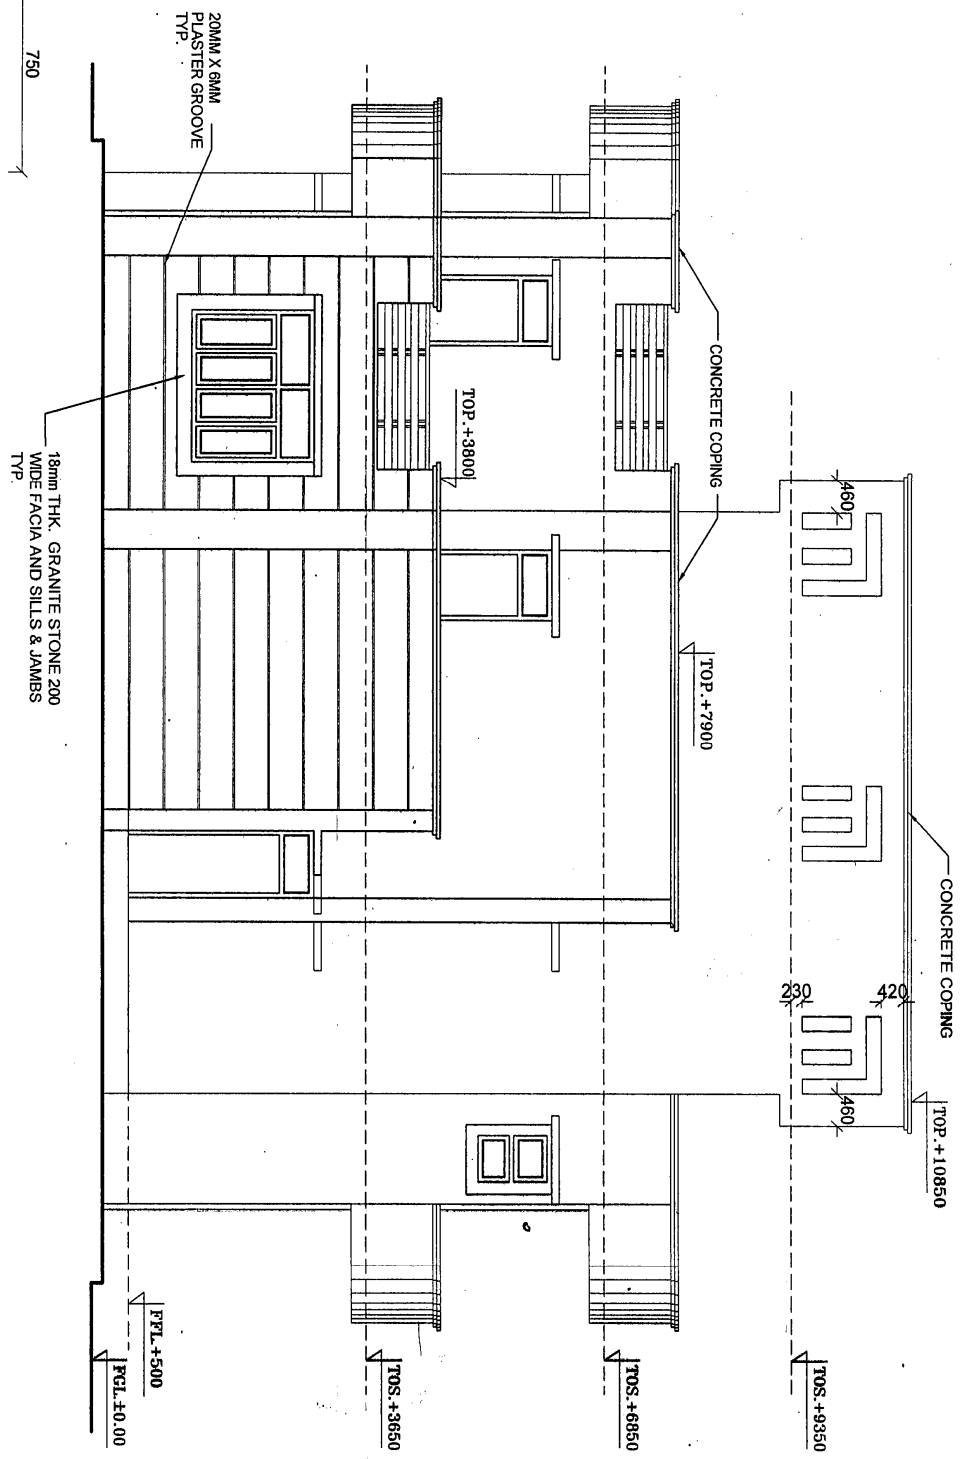

RELEASED FOR TENDER / CONSTRUCTION


**POWER GRID CORPORATION
OF INDIA LIMITED**
(A Government of India Enterprise)



PROJECT: **STANDARD TRANSIT CAMP**

TITLE: **REAR ELEVATION**

CHANGES AS PER REVISED PLAN	PREP (CIVIL)	DESIGN (CIVIL)	DESIGN (CIVIL)	DESIGN (CIVIL)	DATE	SCALE	DRAWING NO.	REV
REV - 01	<i>[Signature]</i>	<i>[Signature]</i>	<i>[Signature]</i>	<i>[Signature]</i>	06/11/14	M/S	G-ENG-STD-TRANSIT CAMP-06	R-01

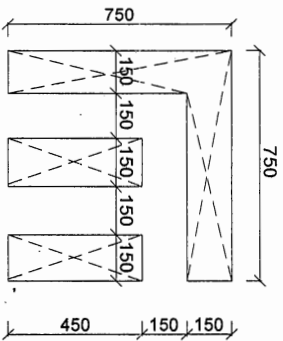

MUMTY PARAPET CUT-OUT
DETAIL TYP.

CHANGES AS PER REVISION PLAN		TITLE: LEFT SIDE ELEVATION	
REV - 02	PREP (CIVIL)	DESIGNED (CIVIL)	DATE
	9/6/14	9/6/14	9/6/14
SCALE NTS		DRAWING NO. C-ENG-STD-TRANSIT CAMP-07	
REV R-02			

RELEASED FOR TENDER / CONSTRUCTION.


PROJECT :

STANDARD TRANSIT CAMP


TITLE: LEFT SIDE ELEVATION

SCALE	DRAWING NO.	REV
1"=10'	C-ENGG-STD-TRANSIT CAMP-07	P-07



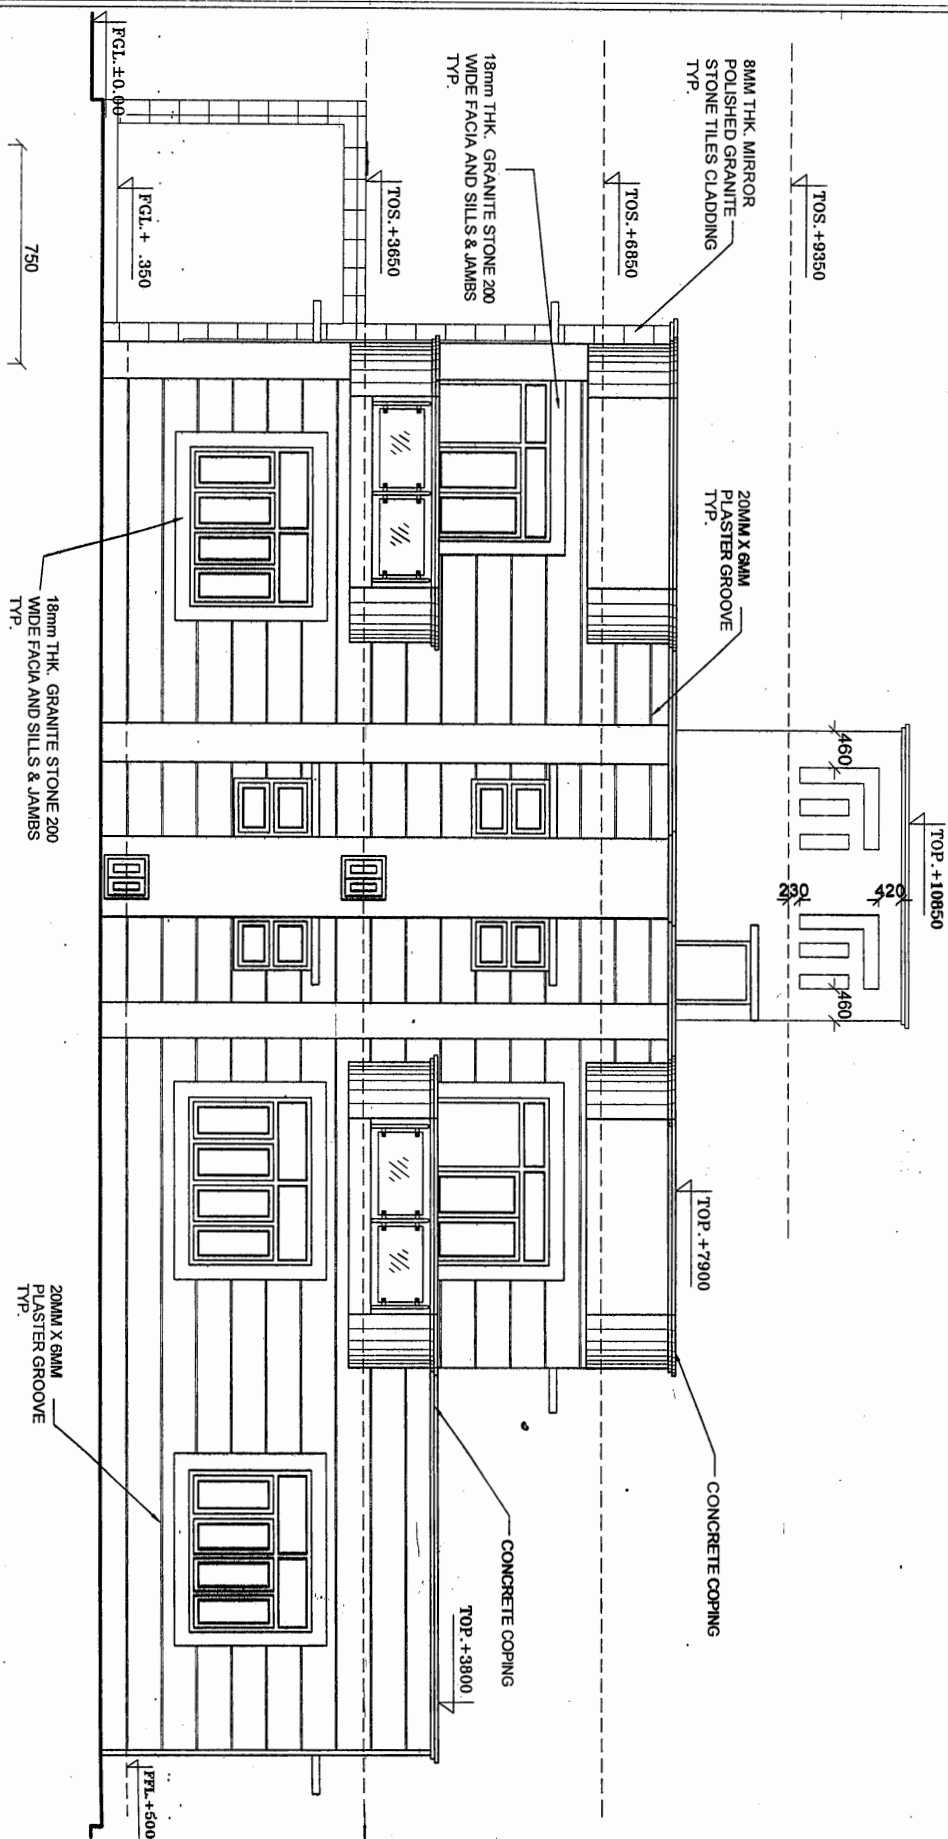

MUMTY PARAPET CUT-OUT
DETAIL TYP.

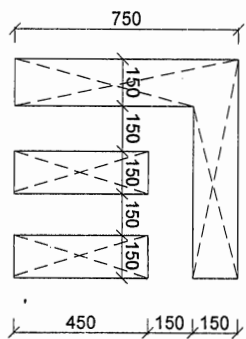

1. DOOR D1 & M1 NOT ADDED ON GRID NO. 4									
2. COLUMN SIZES REVISED AS PER STRUCTURAL REQUIREMENT									
TITLE: RIGHT SIDE ELEVATION									
REV. 02		DDDE (ARCH-DWG)	AGA (ENG-DWG)	GA (ENG-SS & TL)	DATE	SCALE MTS	DRAWING NO.	C-ENG-STD-TRANSIT CAMP-08	REV R-02


PROJECT:
STANDARD TRANSIT CAMP

TITLE:
RIGHT SIDE ELEVATION

POWER GRID CORPORATION
OF INDIA LIMITED
(A Government of India Enterprise)



RELEASED FOR TENDER/CONSTRUCTION

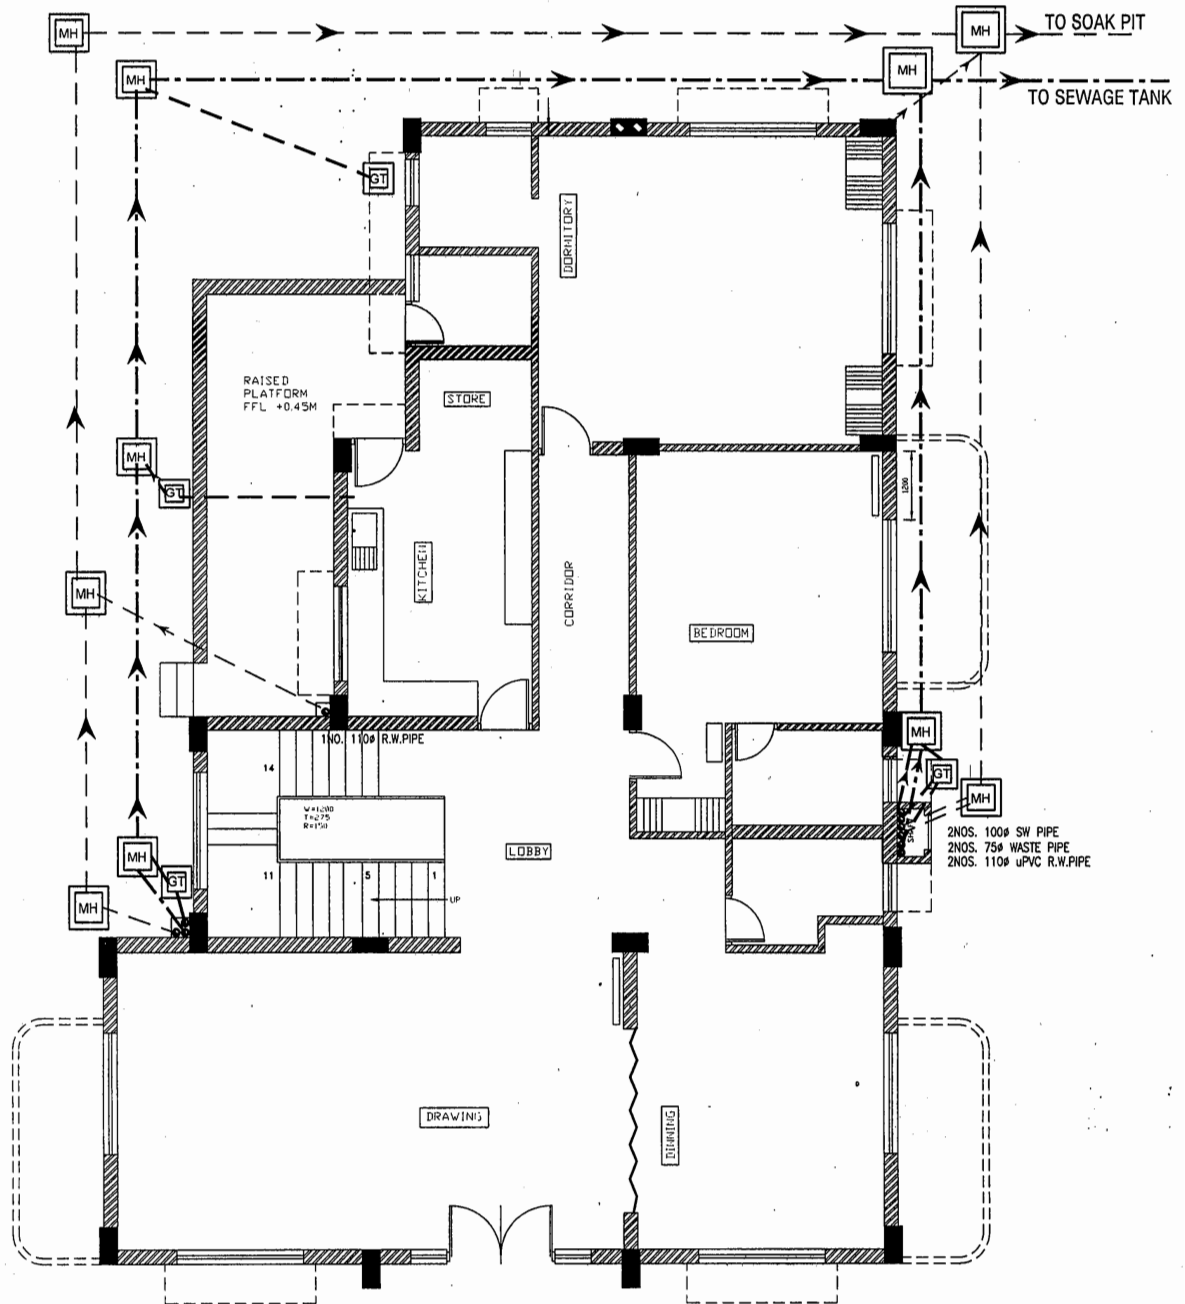

RELEASED FOR TENDER / CONSTRUCTION.

POWER GRID CORPORATION
OF INDIA LIMITED
(A Government of India Enterprise)




PROJECT:

STANDARD TRANSIT CAMP





TITLE:

DRAINAGE & SEWERAGE PLAN

CHANGES AS PER REVISED PLAN	<i>[Signature]</i>	<i>[Signature]</i>	<i>[Signature]</i>	<i>[Signature]</i>	<i>24/2/14</i>	DATE	SCALE NTS	DRAWING NO.	C-ENGG-STD-TRANSIT CAMP-10
REV. - 02	PREP. (CIVIL)	CDE(ENGG- CIVIL)	DGM(ENGG- CIVIL)	GM(ENGG-CIVIL)					

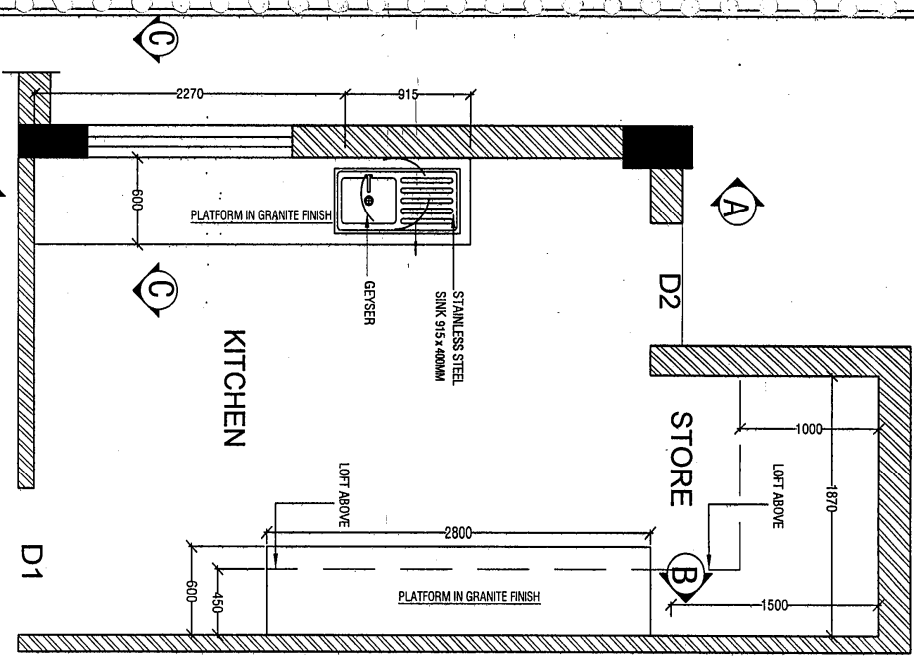

- GENERAL NOTES:**
1. ALL WORK SHALL BE CARRIED OUT AS PER CPWD SPECIFICATIONS (LATEST).
 2. ALL PIPING SHALL BE CONCEALED AND PAINTED WITH ANTI CORROSIIVE BITUMASTIC PAINT.
 3. 2 NOS. C.P. LONG BODY BIB COCK (SI MARKED WEIGHT NOT LESS THAN 690 GMS.) SHALL BE PROVIDED FOR HOT AND COLD WATER FOR THE SINK.
 4. PIPING SHALL BE DONE FOR GEYSER INCLUDING PROVIDING 2 NOS CP BRASS ANGLE VALVE CONFORMING TO IS: 8931 AND SHALL BE CONNECTED WITH CP BRASS CONNECTION PIPE.
 5. SUPPLY OF GEYSER IS NOT IN THE SCOPE.
 6. ONE NO. FLOOR TRAP SHALL BE PROVIDED WITH CP BRASS JALI IN THE FLOOR.
 7. WORK SHALL BE CARRIED OUT AS PER THE DIRECTION OF ENGINEER IN CHARGE

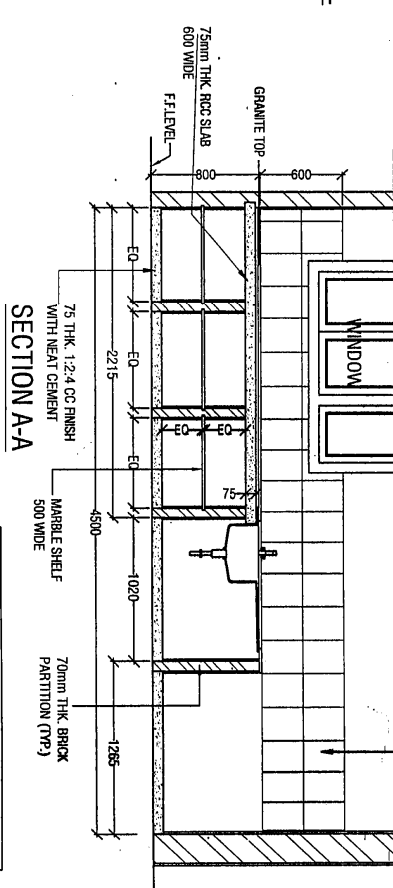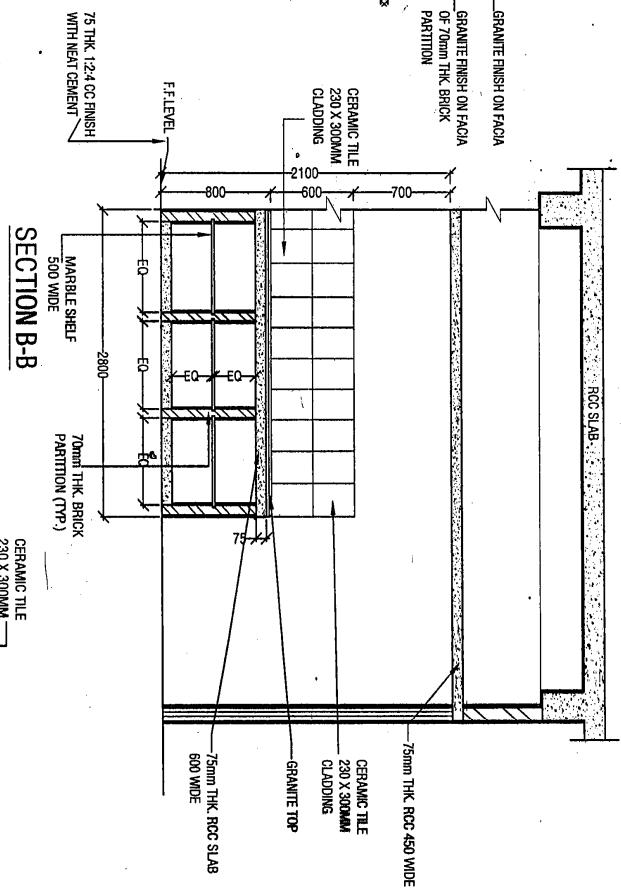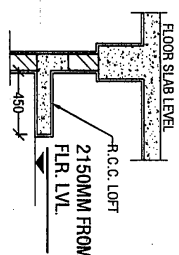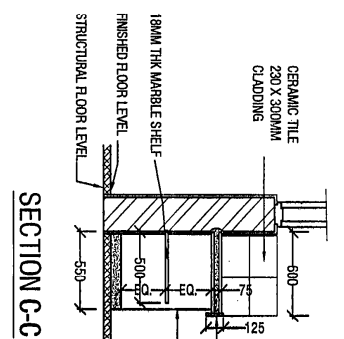

CHANGES AS PER REVISED PLAN


REV.	NO.	DESCRIPTION	DATE	SCALE	DRAWING NO.	REV.
02					C-ENG-STD-TRANSIT CAMP-11	

POWER GRID CORPORATION OF INDIA LIMITED
(A Government of India Enterprise)


STANDARD TRANSIT CAMP




RELEASED FOR TENDER & CONSTRUCTION

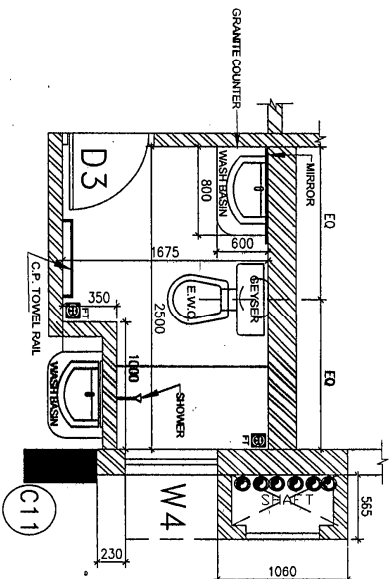


COMMON TOILET
GROUND FLOOR

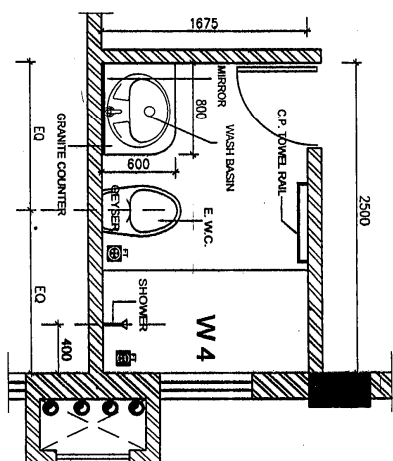


ATTACHED TOILET
GROUND FLOOR

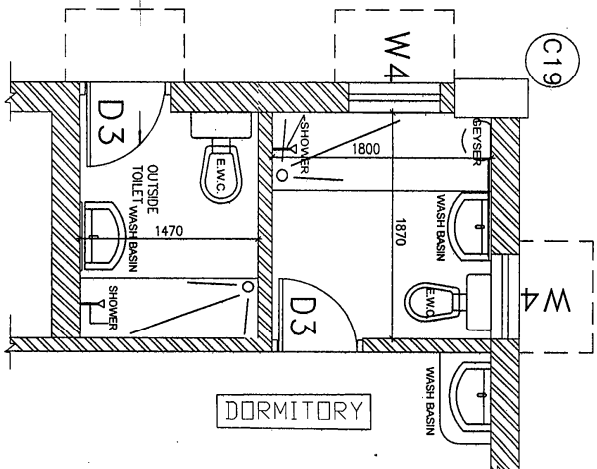

DORMITORY TOILET
GROUND FLOOR

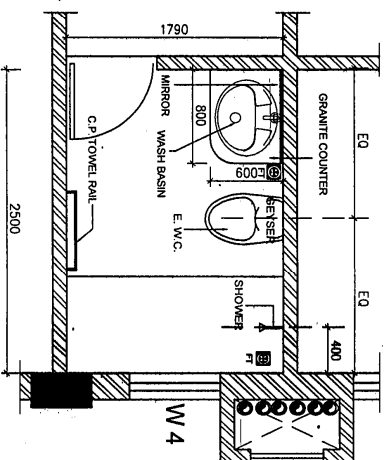

ATTACHED TOILET
FIRST FLOOR

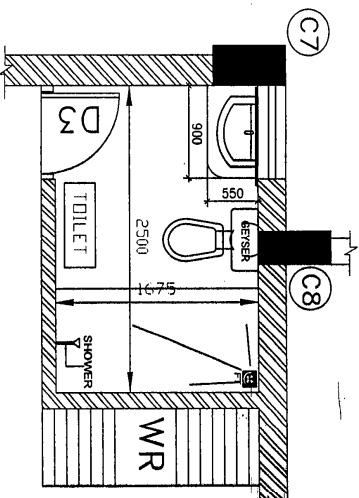

ATTACHED TOILET
FIRST FLOOR

GENERAL NOTES:

1. ALL WORK SHALL BE CARRIED OUT AS PER CPWD SPECIFICATIONS (LATEST).
2. ALL PIPING SHALL BE CONCEALED AND PAINTED WITH ANTI CORROSIVE BITUMASTIC PAINT.
3. 2 NOS. C.P. LONG BODY BIB COCK (S) MARKED (WEIGHT NOT LESS THAN 690 GMS.) SHALL BE PROVIDED FOR HOT AND COLD WATER IN BATH AREA.
4. 2 NOS. C.P. BRASS CONCEALED STOP COCK SHALL BE PROVIDED FOR SHOWER.
5. WASH BASIN SHALL BE PROVIDED WITH CLOSE HOLE BASIN MIXER (WEIGHT NOT LESS THAN 790 GM.) ALONG WITH 2 NOS. ANGLE VALVES. 6. 1 NO. SHORT BODY BIBCOCK CONFORMING TO IS: 8931 SHALL BE PROVIDED FOR E.W.C./RISER PIP.
7. 1 NO. ANGLE VALVE SHALL BE PROVIDED FOR CISTERN CONNECTION.
8. PIPING SHALL BE DONE FOR GEYSER INCLUDING PROVIDING 2 NOS CP BRASS ANGLE VALVE CONFORMING TO IS: 8931 AND SHALL BE CONNECTED WITH CP BRASS CONNECTION PIPE.
9. STANDARD CP BRASS BOTTLE TRAP SHALL BE PROVIDED FOR BASIN OUTLET.
10. 2 NOS. FLOOR TRAP SHALL BE PROVIDED WITH CP BRASS JAU IN THE FLOOR.
11. 600X450 MM SIZE GMM THK. BEVELED EDGE MIRROR SHALL BE PROVIDED ABOVE WASH BASIN.
12. C.P. BRASS TOWEL RAIL AND C.P. BRASS SOAP DISH SHALL BE PROVIDED.
13. C.P. BRASS PAPER HOLDER SHALL BE PROVIDED FOR EACH E.W.C.
14. WORK SHALL BE CARRIED OUT AS PER THE DIRECTION OF ENGINEER IN CHARGE.
15. ALL ATTACHED TOILETS OF BED ROOMS SHALL HAVE TELEPHONIC SHOWER.

RELEASED FOR TENDER & CONSTRUCTION.


POWER GRID CORPORATION
OF INDIA LIMITED
(A Government of India Enterprise)




PROJECT: STANDARD DRAWINGS FOR TRANSIT CAMP

TITLE: TOILET DETAILS

CHANGES AS PER REVISED PLAN	PREP. (CIVIL)	CHKD. (CIVIL)	DOING (CIVIL)	DATE	SCALE	DRAWING NO.	REV.
REV - 02					NTS	C-ENG-STD-TRANSIT CAMP-13	R-02

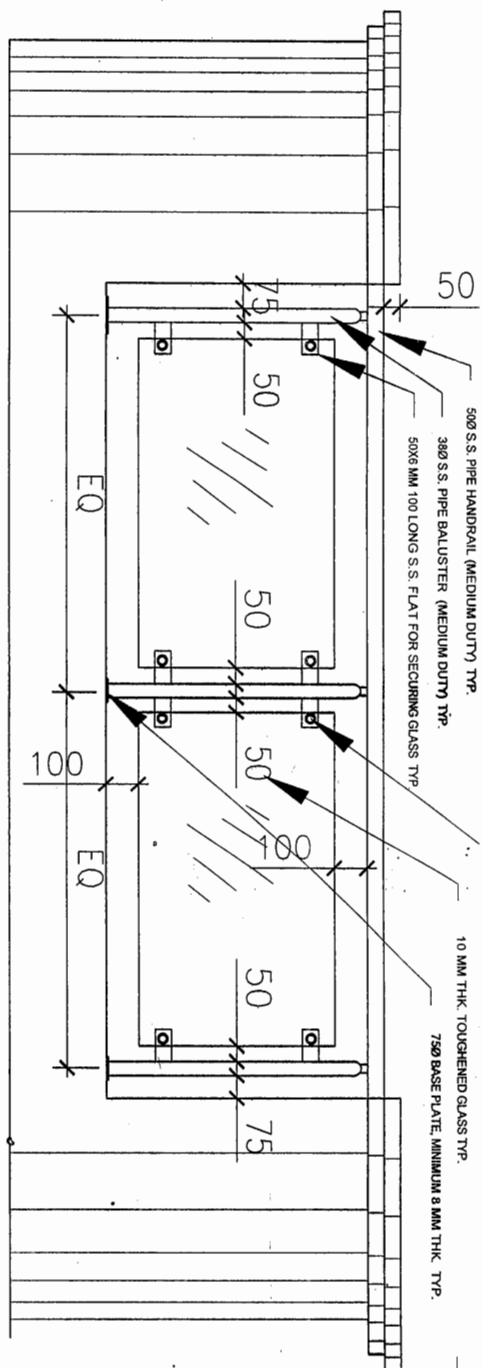

ELEVATION

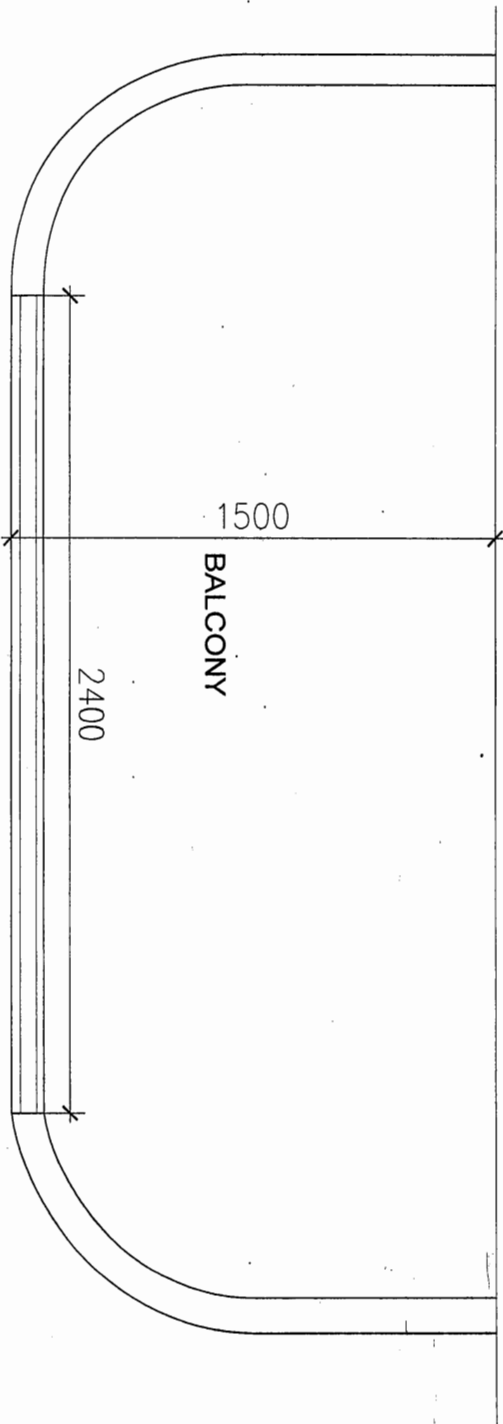

PLAN

- NOTES:-
1. ALL STAINLESS STEEL SHALL BE OF GRADE AISI 316.
 2. WELDING OF STAINLESS STEEL SHALL BE DONE AS PER RELEVANT IS : CODE
 3. GRINDING, POLISHING AND BUFFING ETC SHALL BE DONE AS PER DIRECTION OF E.I.C.

RELEASED FOR TENDER / CONSTRUCTION

TITLE: BALCONY RAILING DETAILS

PROJECT: STANDARD TRANSIT CAMP


POWER GRID CORPORATION
OF INDIA LIMITED
(A Government of India Enterprise)



DOOR (ENGG-CIVIL)	AGM (ENGG-CIVIL)	GM (ENGG-SS & TV)	DATE	SCALE NTS	DRAWING NO.	REV.
					C-ENGG-STD-TRANSIT CAMP-15	R-00

SYMBOL	ITEM DESCRIPTION	ABBREVIATION DETAIL
	TELEPHONE BOX/TELEVISION BOX	TB
	DISTRIBUTION BOARD Type: A	DB
	SWITCH BOARD WITHOUT GAMP SOCKET	SBA
	SWITCH BOARD WITH GAMP SOCKET	SBC
	TELEPHONE POINT	TP
	TELEVISION POINT	TV
	AIR-CONDITIONER POINT WITH 15 A SWITCH	RAC
	15A POWER POINT WITH 15 A SWITCH	RB
	5A POWER POINT WITH 5 A SWITCH	RA
	1x18W PL FITTING	TL- LED
	BRACKET LIGHTS	BL- LED
	SPOT LIGHTS (DOWN LIGHT)	SL- LED
	BULK HEAD LIGHT	BH-LED
	CHANDELIER	CH- LED
	EXHAUST FAN	EFC
	CEILING FAN	CFC

	TELEPHONE POINT CONDUITS
	TELEVISION POINT CONDUITS
	LIGHT & 5A SOCKET CONDUITS
	POWER CONDUIT
	A/C CONDUIT
	SUB MAIN

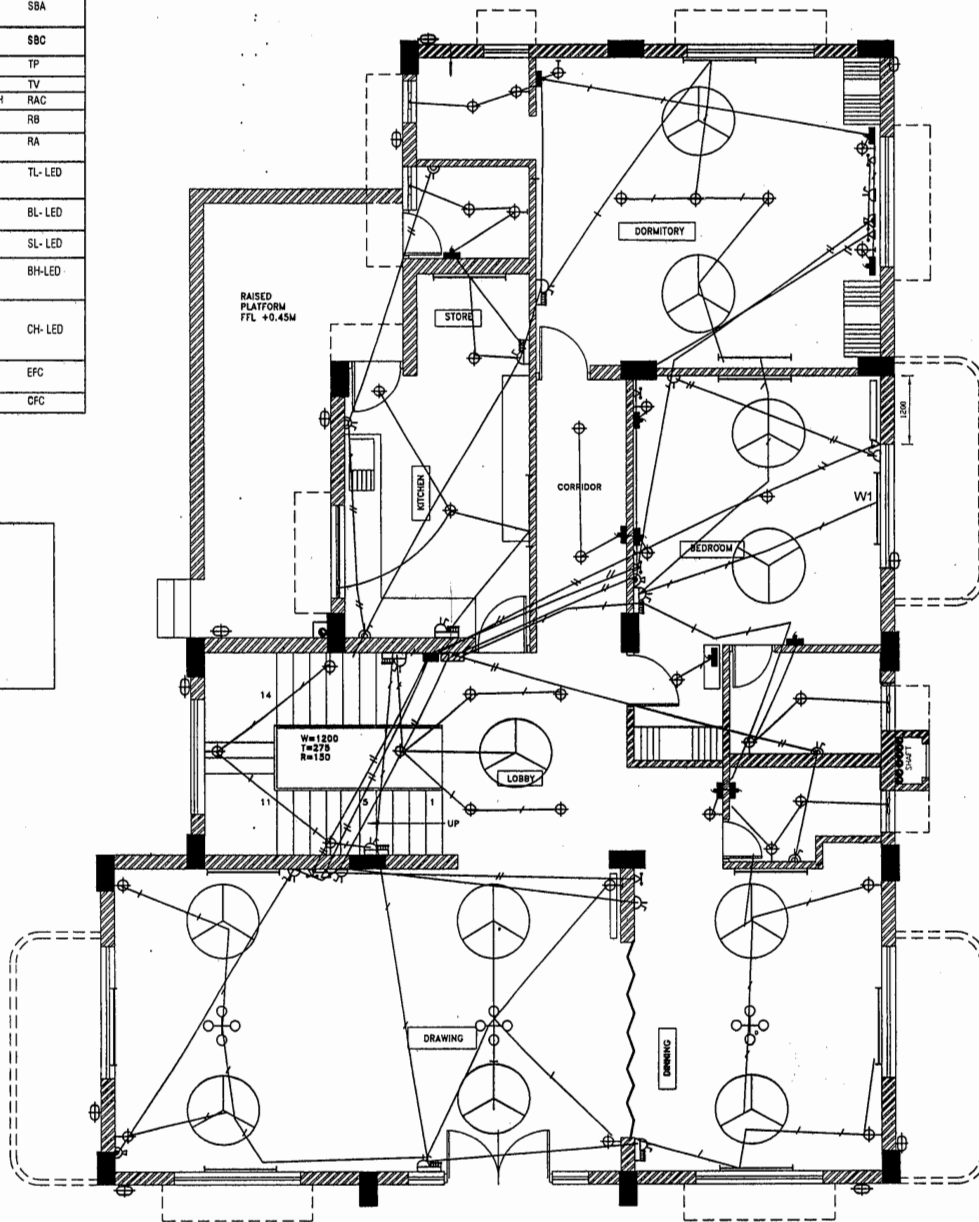

NOTES:

1. THIS DRAWING SHALL BE REFERRED ONLY FOR LIGHTING PURPOSE.

RELEASED FOR TENDER / CONSTRUCTION.

POWER GRID CORPORATION
OF INDIA LIMITED
(A Government of India Enterprise)



PROJECT: **STANDARD TRANSIT CAMP**


TITLE: GROUND FLOOR PLAN

CHANGES AS PER REVISED PLAN					16/11/21	TITLE: GROUND FLOOR PLAN		
						SCALE NTS	DRAWING NO. C/ENGG/STD/TRANSIT CAMP/ELECT/04	REV 03
REV. - 03	SR.ENGR.(ENGG-SS)	CDE(ENGG-CIVIL)	DGM(ENGG-SS)	AGM(ENGG-SS)	GM(ENGG-SS&TL) DATE			

SCALE NTS	DRAWING NO. C/ENGG/STD/TRANSIT CAMP/ELECT/04	REV 03
--------------	--	-----------

SYMBOL	ITEM DESCRIPTION	ABBREVIATION DETAIL
	TELEPHONE BOX/TELEVISION BOX	TB
	DISTRIBUTION BOARD Type: A	DB
	SWITCH BOARD WITHOUT GAMP SOCKET	SBA
	SWITCH BOARD WITH GAMP SOCKET	SBC
	TELEPHONE POINT	TP
	TELEVISION POINT	TV
	AIR-CONDITIONER POINT WITH 15 A SWITCH	RAC
	15A POWER POINT WITH 15 A SWITCH	RB
	5A POWER POINT WITH 5 A SWITCH	RA
	1x18W PL FITTING	TL- LED
	BRACKET LIGHTS	BL- LED
	SPOT LIGHTS (DOWN LIGHT)	SL- LED
	BULK HEAD LIGHT	BH- LED
	CHANDELIER	CH- LED
	EXHAUST FAN	EFC
	CEILING FAN	CFC

	TELEPHONE POINT CONDUITS
	TELEVISION POINT CONDUITS
	LIGHT & 5A SOCKET CONDUITS
	POWER CONDUIT
	A/C CONDUIT
	SUB MAIN

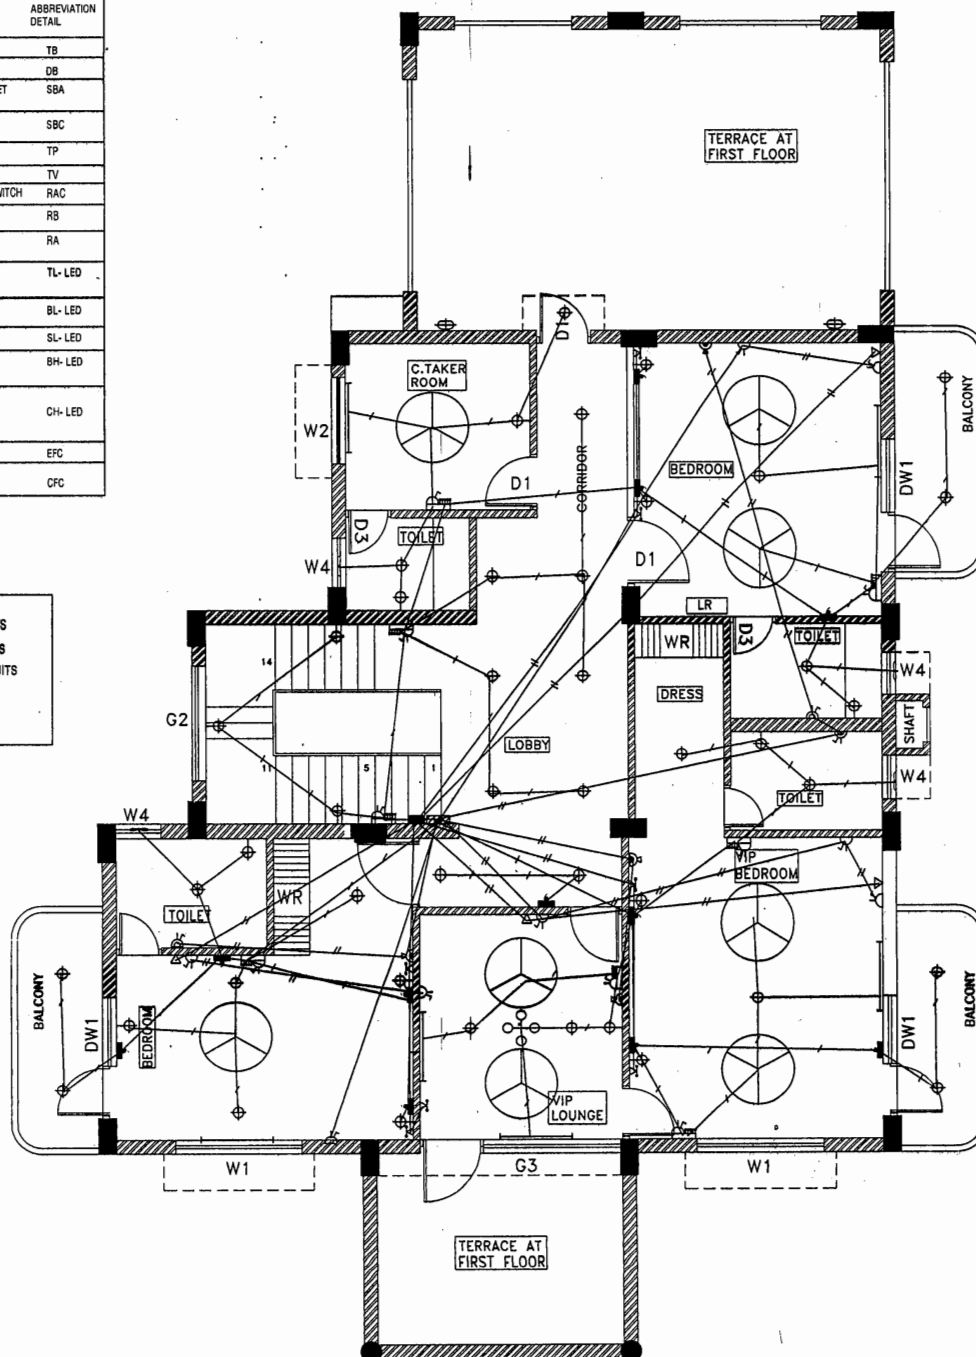

NOTES:

1. THIS DRAWING SHALL BE REFERRED ONLY
FOR LIGHTING PURPOSE.

RELEASED FOR TENDER / CONSTRUCTION.

POWER GRID CORPORATION
OF INDIA LIMITED
(A Government of India Enterprise)




PROJECT:


STANDARD TRANSIT CAMP

TITLE: FIRST FLOOR PLAN

CHANGES AS PER REVISED PLAN							TITLE: FIRST FLOOR PLAN		
REV. - 03	SR.ENGR.(ENGG.SB)	CDE(ENGG-CIVIL)	DOM(ENGG-SS)	AGM(ENGG-SB)	GM(ENGG-SS&ETL)	DATE	SCALE NTS	DRAWING NO. C/ENGG/STD/TRANSIT CAMP/ELECT/04a	REV 03

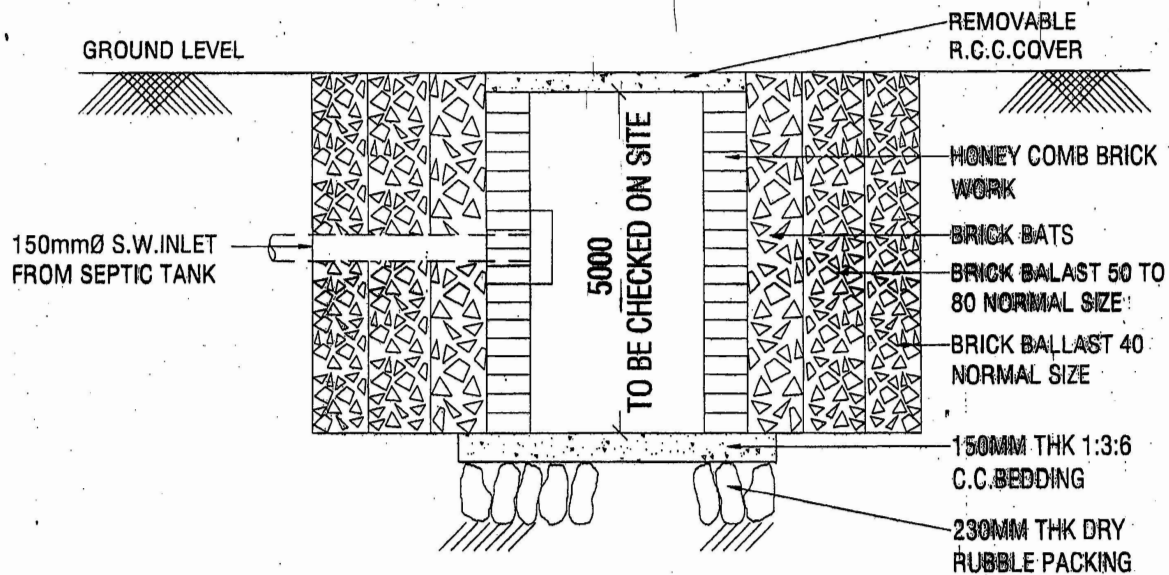

SECTION AT Z-Z'

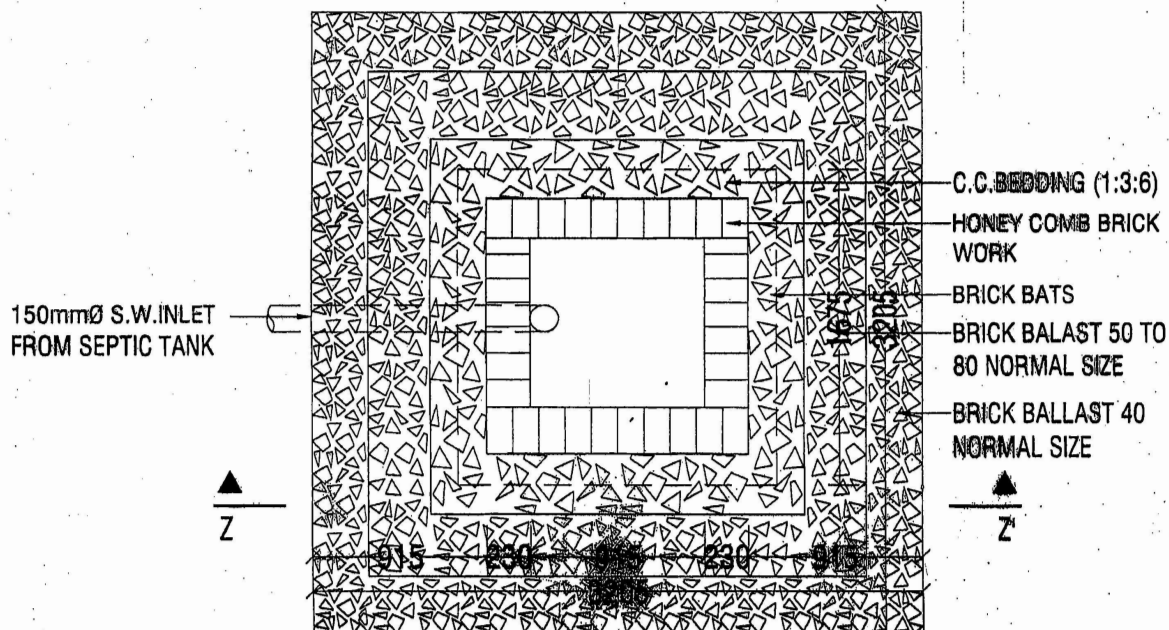

PLAN-SOAK PIT

RELEASED FOR TENDER & CONSTRUCTION.

POWER GRID CORPORATION
OF INDIA LIMITED
(A Government of India Enterprise)



PROJECT :

STANDARD DRAWINGS FOR TOWNSHIP

TITLE :

PLAN-SOAK PIT

<i>Deban</i>	<i>K.P.</i>	<i>GM</i>	<i>GM</i>
DCDE (ENGG-CIVIL)	AGM (ENGG-CIVIL)	AGM (ENGG-CIVIL)	GM (ENGG-BB/TL)

DATE

19/10/2019

SCALE

NTS

DRAWING NO.

C/ENGG/TS/STD/COMMON/19


REV

R-0



PLAN OF SEPTIC TANK

1. ALL DIMENSIONS ARE IN MM.
2. DO NOT SCALE THE DRAWING AND FOLLOW WRITTEN DIMENSIONS ONLY.
3. ALL R.C.C. SHALL BE OF MAX 1:1.5:3, MIXED WITH WATER PROOFING ADJUTANT AS PER RECOMMENDATION OF MANUFACTURER.
4. SLOPE 1:100 SHALL BE PROVIDED IN TANK FLOOR AND ROOF SLAB
5. ALL BRICK SHALL BE OF CLASS DESIGNATION 7.5
6. DISCREPANCY, IF ANY IN THE DRAWINGS SHALL BE BROUGHT TO THE NOTICE OF SITE IN CHARGE
7. ALL WORK SHALL BE CARRIED OUT AS PER GIVEN SPECIFICATIONS AND AS PER DIRECTION OF E.T.C.

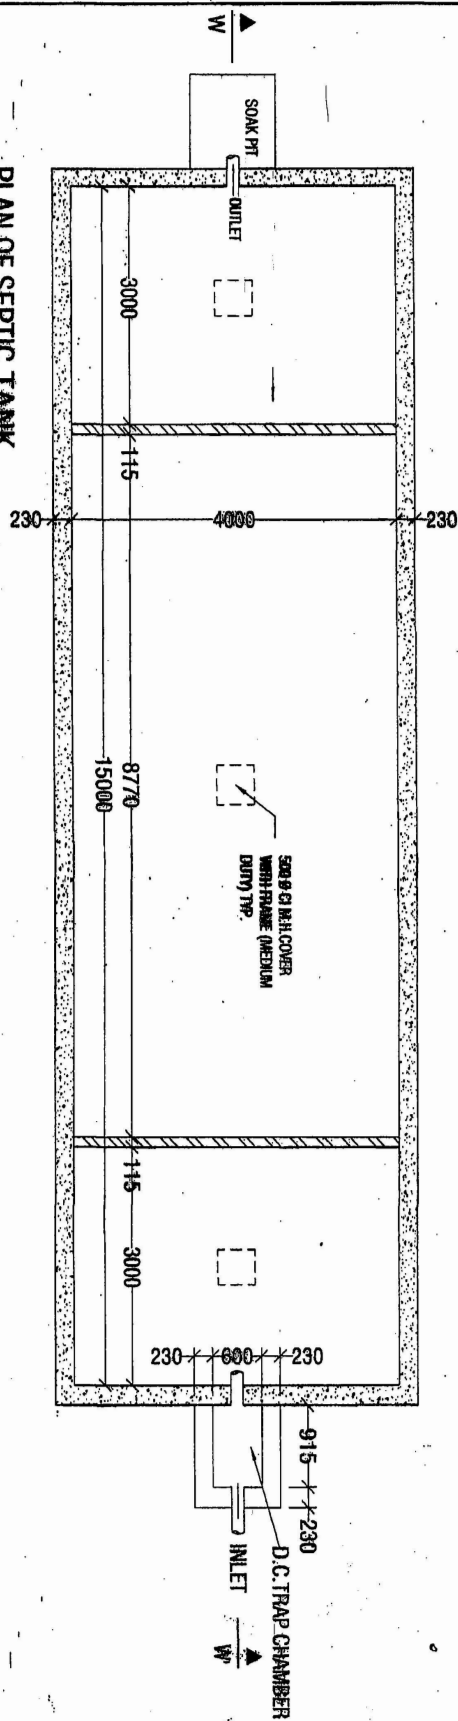

TITLE: SEPTIC TANK DETAILS		DATE	10/11/2019
DRAWING NO. C/ENGC/TS/STD/COMMON/14	SCALE MTS	NAME (ENGC-CIVIL)	SIGN (ENGC-CIVIL)

RELEASED FOR TENDER & CONSTRUCTION.

**POWER GRID CORPORATION
OF INDIA LIMITED**
(A Government of India Enterprise)

PROJECT :

STANDARD DRAWINGS FOR TOWNSHIP

NE:

SEPTIC TANK DETAILS

SCALE NTS	DRAWING NO.	C/ENGG/TS/STD/COMMON/14
--------------	-------------	-------------------------

R-01