

FIFTH FLOOR PLAN
 Height 3.30 M HEIGHT
 TRAINEE HOSTEL ROOM - 12 NOS.

LEGEND	SYMBOL	DESCRIPTION	LEGEND	SYMBOL	DESCRIPTION
1	[Symbol]	1. T.C. POINT	1	[Symbol]	1. T.C. POINT
2	[Symbol]	2. ELECTRIC POINT	2	[Symbol]	2. ELECTRIC POINT
3	[Symbol]	3. WATER POINT	3	[Symbol]	3. WATER POINT
4	[Symbol]	4. DRAIN POINT	4	[Symbol]	4. DRAIN POINT
5	[Symbol]	5. T.V. POINT	5	[Symbol]	5. T.V. POINT
6	[Symbol]	6. GAS POINT	6	[Symbol]	6. GAS POINT
7	[Symbol]	7. FIRE POINT	7	[Symbol]	7. FIRE POINT
8	[Symbol]	8. T.V. POINT	8	[Symbol]	8. T.V. POINT
9	[Symbol]	9. T.V. POINT	9	[Symbol]	9. T.V. POINT
10	[Symbol]	10. T.V. POINT	10	[Symbol]	10. T.V. POINT
11	[Symbol]	11. T.V. POINT	11	[Symbol]	11. T.V. POINT
12	[Symbol]	12. T.V. POINT	12	[Symbol]	12. T.V. POINT
13	[Symbol]	13. T.V. POINT	13	[Symbol]	13. T.V. POINT
14	[Symbol]	14. T.V. POINT	14	[Symbol]	14. T.V. POINT
15	[Symbol]	15. T.V. POINT	15	[Symbol]	15. T.V. POINT
16	[Symbol]	16. T.V. POINT	16	[Symbol]	16. T.V. POINT
17	[Symbol]	17. T.V. POINT	17	[Symbol]	17. T.V. POINT
18	[Symbol]	18. T.V. POINT	18	[Symbol]	18. T.V. POINT
19	[Symbol]	19. T.V. POINT	19	[Symbol]	19. T.V. POINT
20	[Symbol]	20. T.V. POINT	20	[Symbol]	20. T.V. POINT
21	[Symbol]	21. T.V. POINT	21	[Symbol]	21. T.V. POINT
22	[Symbol]	22. T.V. POINT	22	[Symbol]	22. T.V. POINT
23	[Symbol]	23. T.V. POINT	23	[Symbol]	23. T.V. POINT
24	[Symbol]	24. T.V. POINT	24	[Symbol]	24. T.V. POINT
25	[Symbol]	25. T.V. POINT	25	[Symbol]	25. T.V. POINT
26	[Symbol]	26. T.V. POINT	26	[Symbol]	26. T.V. POINT
27	[Symbol]	27. T.V. POINT	27	[Symbol]	27. T.V. POINT
28	[Symbol]	28. T.V. POINT	28	[Symbol]	28. T.V. POINT
29	[Symbol]	29. T.V. POINT	29	[Symbol]	29. T.V. POINT
30	[Symbol]	30. T.V. POINT	30	[Symbol]	30. T.V. POINT

NO.	REVISION	DATE	BY	CHECKED	DESCRIPTION
1	ISSUED FOR PERMIT	15/03/2023	[Name]	[Name]	ISSUED FOR PERMIT
2	ISSUED FOR TENDER	15/03/2023	[Name]	[Name]	ISSUED FOR TENDER

TENDER DRAWING

POWER GRID CORPORATION
 POWER GRID CORPORATION
 POWER GRID CORPORATION

PROJECT NAME: TRAINEE HOSTEL ROOM - 12 NOS.

PROJECT LOCATION: [Address]


DATE: 15/03/2023

SCALE: AS SHOWN

DESIGNED BY: [Name]

CHECKED BY: [Name]

APPROVED BY: [Name]

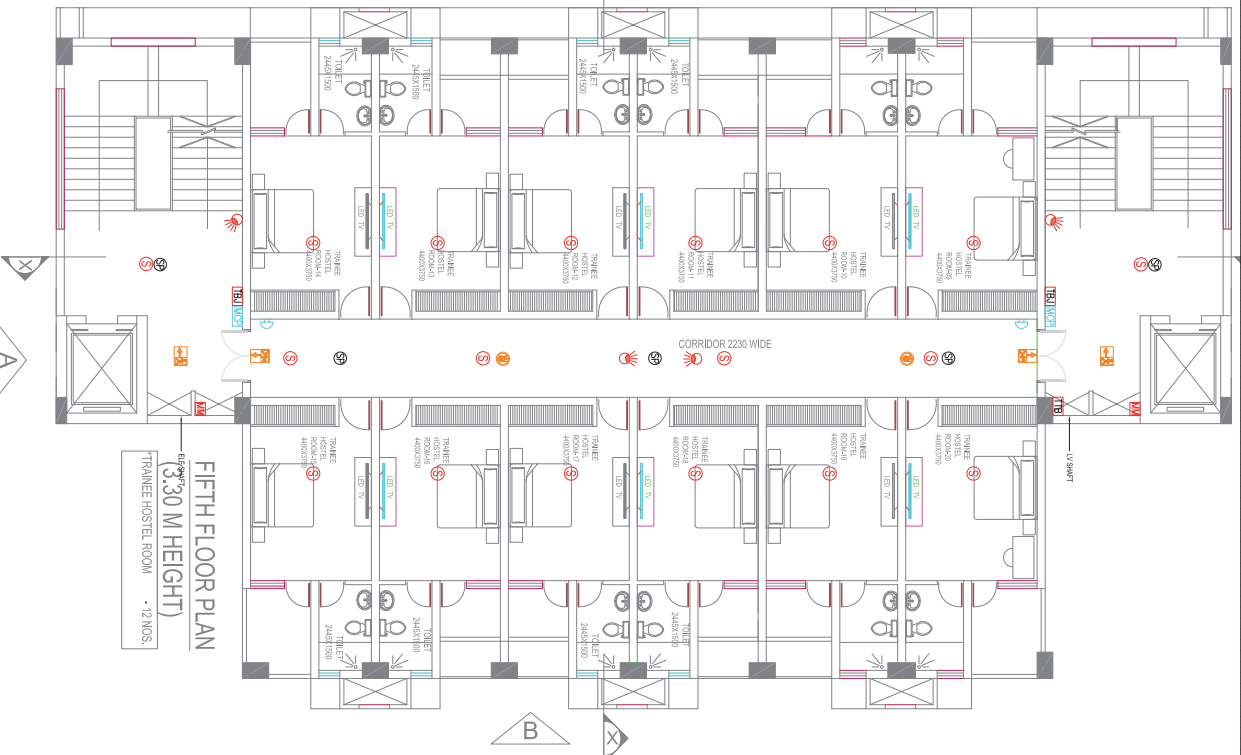

FIFTH FLOOR PLAN
 Height 3.30 M HEIGHT
 TRAINEE HOSTEL ROOM - 12 NOS.

LEGEND	SYMBOL	DESCRIPTION	LEGEND	SYMBOL	DESCRIPTION
1	[Symbol]	1. T.C. POINT	1	[Symbol]	1. T.C. POINT
2	[Symbol]	2. ELECTRIC POINT	2	[Symbol]	2. ELECTRIC POINT
3	[Symbol]	3. WATER POINT	3	[Symbol]	3. WATER POINT
4	[Symbol]	4. DRAIN POINT	4	[Symbol]	4. DRAIN POINT
5	[Symbol]	5. T.V. POINT	5	[Symbol]	5. T.V. POINT
6	[Symbol]	6. GAS POINT	6	[Symbol]	6. GAS POINT
7	[Symbol]	7. FIRE POINT	7	[Symbol]	7. FIRE POINT
8	[Symbol]	8. T.V. POINT	8	[Symbol]	8. T.V. POINT
9	[Symbol]	9. T.V. POINT	9	[Symbol]	9. T.V. POINT
10	[Symbol]	10. T.V. POINT	10	[Symbol]	10. T.V. POINT
11	[Symbol]	11. T.V. POINT	11	[Symbol]	11. T.V. POINT
12	[Symbol]	12. T.V. POINT	12	[Symbol]	12. T.V. POINT
13	[Symbol]	13. T.V. POINT	13	[Symbol]	13. T.V. POINT
14	[Symbol]	14. T.V. POINT	14	[Symbol]	14. T.V. POINT
15	[Symbol]	15. T.V. POINT	15	[Symbol]	15. T.V. POINT
16	[Symbol]	16. T.V. POINT	16	[Symbol]	16. T.V. POINT
17	[Symbol]	17. T.V. POINT	17	[Symbol]	17. T.V. POINT
18	[Symbol]	18. T.V. POINT	18	[Symbol]	18. T.V. POINT
19	[Symbol]	19. T.V. POINT	19	[Symbol]	19. T.V. POINT
20	[Symbol]	20. T.V. POINT	20	[Symbol]	20. T.V. POINT
21	[Symbol]	21. T.V. POINT	21	[Symbol]	21. T.V. POINT
22	[Symbol]	22. T.V. POINT	22	[Symbol]	22. T.V. POINT
23	[Symbol]	23. T.V. POINT	23	[Symbol]	23. T.V. POINT
24	[Symbol]	24. T.V. POINT	24	[Symbol]	24. T.V. POINT
25	[Symbol]	25. T.V. POINT	25	[Symbol]	25. T.V. POINT
26	[Symbol]	26. T.V. POINT	26	[Symbol]	26. T.V. POINT
27	[Symbol]	27. T.V. POINT	27	[Symbol]	27. T.V. POINT
28	[Symbol]	28. T.V. POINT	28	[Symbol]	28. T.V. POINT
29	[Symbol]	29. T.V. POINT	29	[Symbol]	29. T.V. POINT
30	[Symbol]	30. T.V. POINT	30	[Symbol]	30. T.V. POINT

TENDER DRAWING

POWER GRID CORPORATION
 POWER GRID CORPORATION
 POWER GRID CORPORATION

PROJECT NAME: TRAINEE HOSTEL ROOM - 12 NOS.

PROJECT LOCATION: [Address]

DATE: 15/03/2023

SCALE: AS SHOWN

DESIGNED BY: [Name]

CHECKED BY: [Name]

APPROVED BY: [Name]

Typical Detail: Room Wiring Schematic

Room: TRAINEE HOSTEL ROOM

Room No: 204/1500

Room Size: 12.00 M²

Room Type: Single Room

Room Category: Hostel

Room Location: Fifth Floor

Room Orientation: North

Room Area: 12.00 M²

Room Volume: 39.60 M³

Room Height: 3.30 M

Room Area: 12.00 M²


Room Volume: 39.60 M³

Room Height: 3.30 M

Room Area: 12.00 M²

Room Volume: 39.60 M³

Room Height: 3.30 M

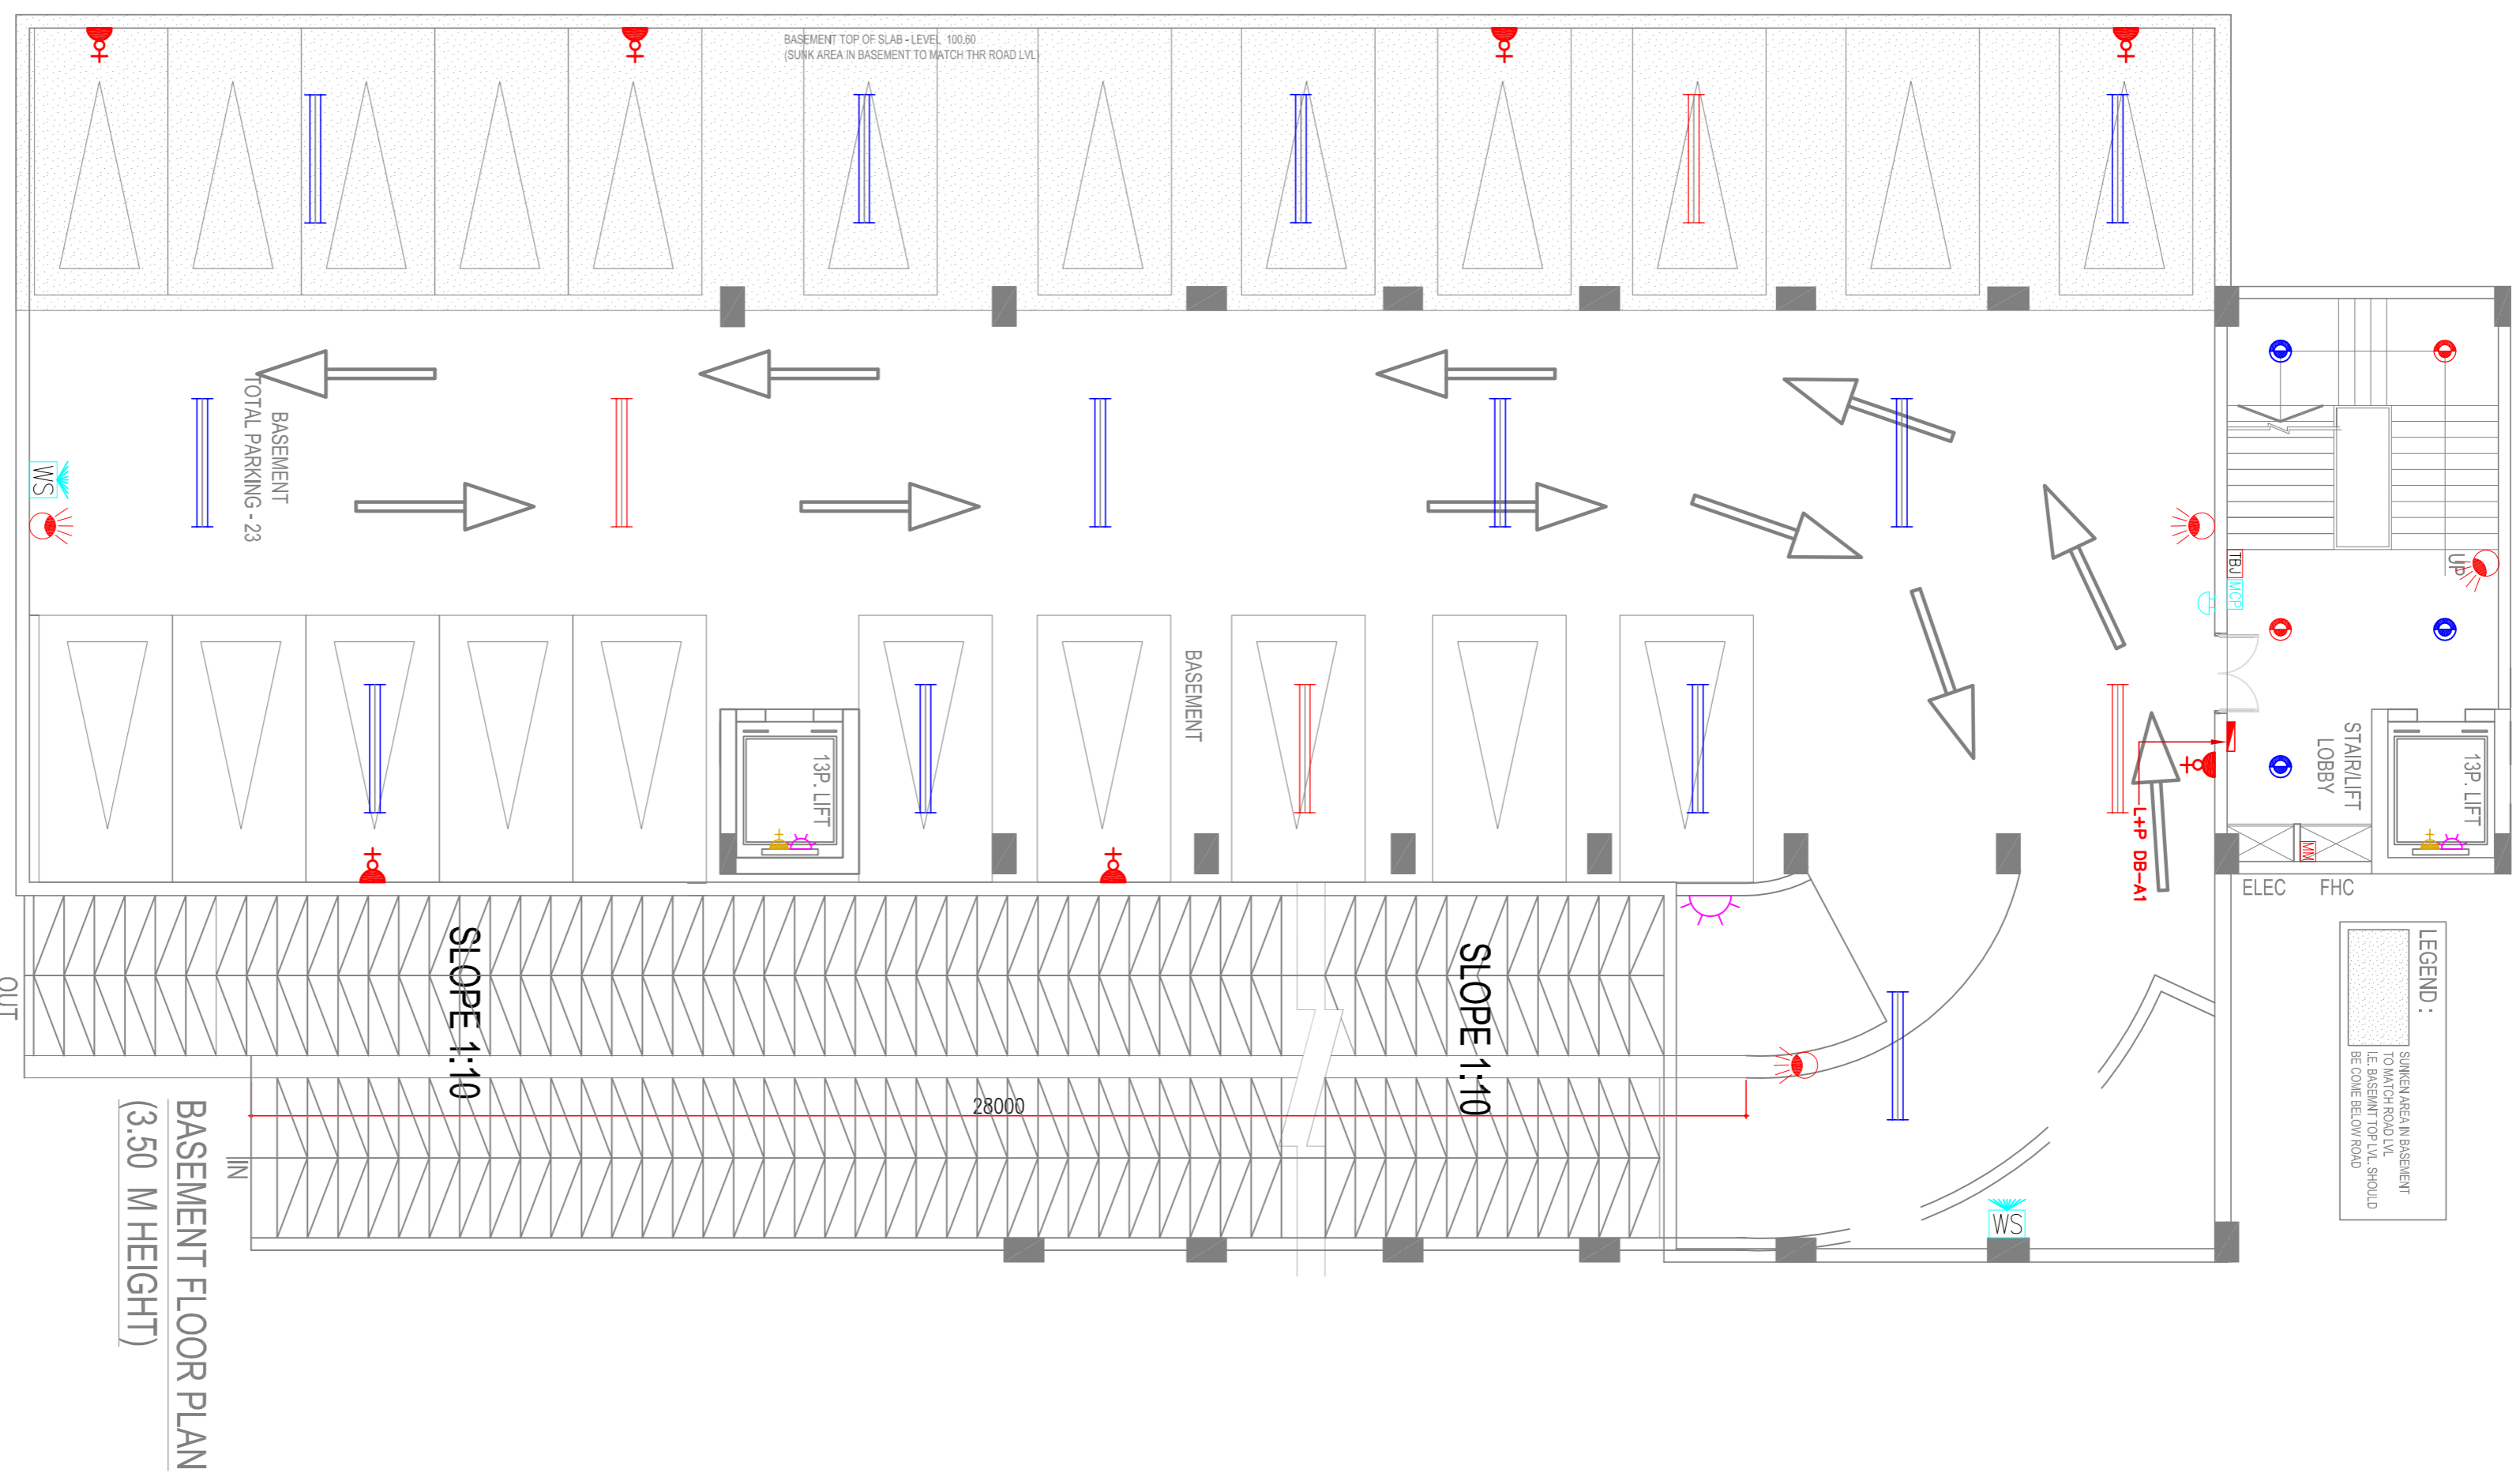

BASEMENT FLOOR PLAN
(3.50 M HEIGHT)

LEGENDS:-

17	BS	BASEMENT TOP OF SLAB - LEVEL 100.60
18	HS	HOSTEL
19	BD	BACK DOOR
20	MD	MONITOR MONITOR

LEGENDS:-

1	BLK	BLACK HEAD LIGHT
2	LD	LED BASED DOWN LIGHT
3	LD	LED BASED DOWN LIGHT
4	LD	LED BASED DOWN LIGHT
5	LD	LED BASED DOWN LIGHT
6	LD	LED BASED DOWN LIGHT
7	LD	LED BASED DOWN LIGHT
8	LD	LED BASED DOWN LIGHT
9	LD	LED BASED DOWN LIGHT
10	LD	LED BASED DOWN LIGHT
11	LD	LED BASED DOWN LIGHT
12	LD	LED BASED DOWN LIGHT
13	LD	LED BASED DOWN LIGHT
14	LD	LED BASED DOWN LIGHT
15	LD	LED BASED DOWN LIGHT
16	LD	LED BASED DOWN LIGHT

POWER GRID CORPORATION OF INDIA LIMITED

TENDER DRAWING

REVISIONS

NO.	DESCRIPTION	DATE
1	ISSUED FOR TENDER	15/08/2024

PROJECT: POWER GRID CORPORATION OF INDIA LIMITED, VANDANVA

DESIGNED BY: POWER GRID CORPORATION OF INDIA LIMITED, VANDANVA

CHECKED BY: POWER GRID CORPORATION OF INDIA LIMITED, VANDANVA

DATE: 15/08/2024

SCALE: AS SHOWN

PRODUCT MANUFACTURER: PANJAB KUMAR

PROJECT MANAGER: POWER GRID CORPORATION OF INDIA LIMITED, VANDANVA

APPROVED BY: POWER GRID CORPORATION OF INDIA LIMITED, VANDANVA

DATE: 15/08/2024

PROJECT: POWER GRID CORPORATION OF INDIA LIMITED, VANDANVA

DESIGNED BY: POWER GRID CORPORATION OF INDIA LIMITED, VANDANVA

CHECKED BY: POWER GRID CORPORATION OF INDIA LIMITED, VANDANVA

DATE: 15/08/2024

SCALE: AS SHOWN

PRODUCT MANUFACTURER: PANJAB KUMAR

PROJECT MANAGER: POWER GRID CORPORATION OF INDIA LIMITED, VANDANVA

APPROVED BY: POWER GRID CORPORATION OF INDIA LIMITED, VANDANVA

DATE: 15/08/2024

PROJECT: POWER GRID CORPORATION OF INDIA LIMITED, VANDANVA

DESIGNED BY: POWER GRID CORPORATION OF INDIA LIMITED, VANDANVA

CHECKED BY: POWER GRID CORPORATION OF INDIA LIMITED, VANDANVA

DATE: 15/08/2024



SCALE: AS SHOWN

PRODUCT MANUFACTURER: PANJAB KUMAR

PROJECT MANAGER: POWER GRID CORPORATION OF INDIA LIMITED, VANDANVA

APPROVED BY: POWER GRID CORPORATION OF INDIA LIMITED, VANDANVA

DATE: 15/08/2024

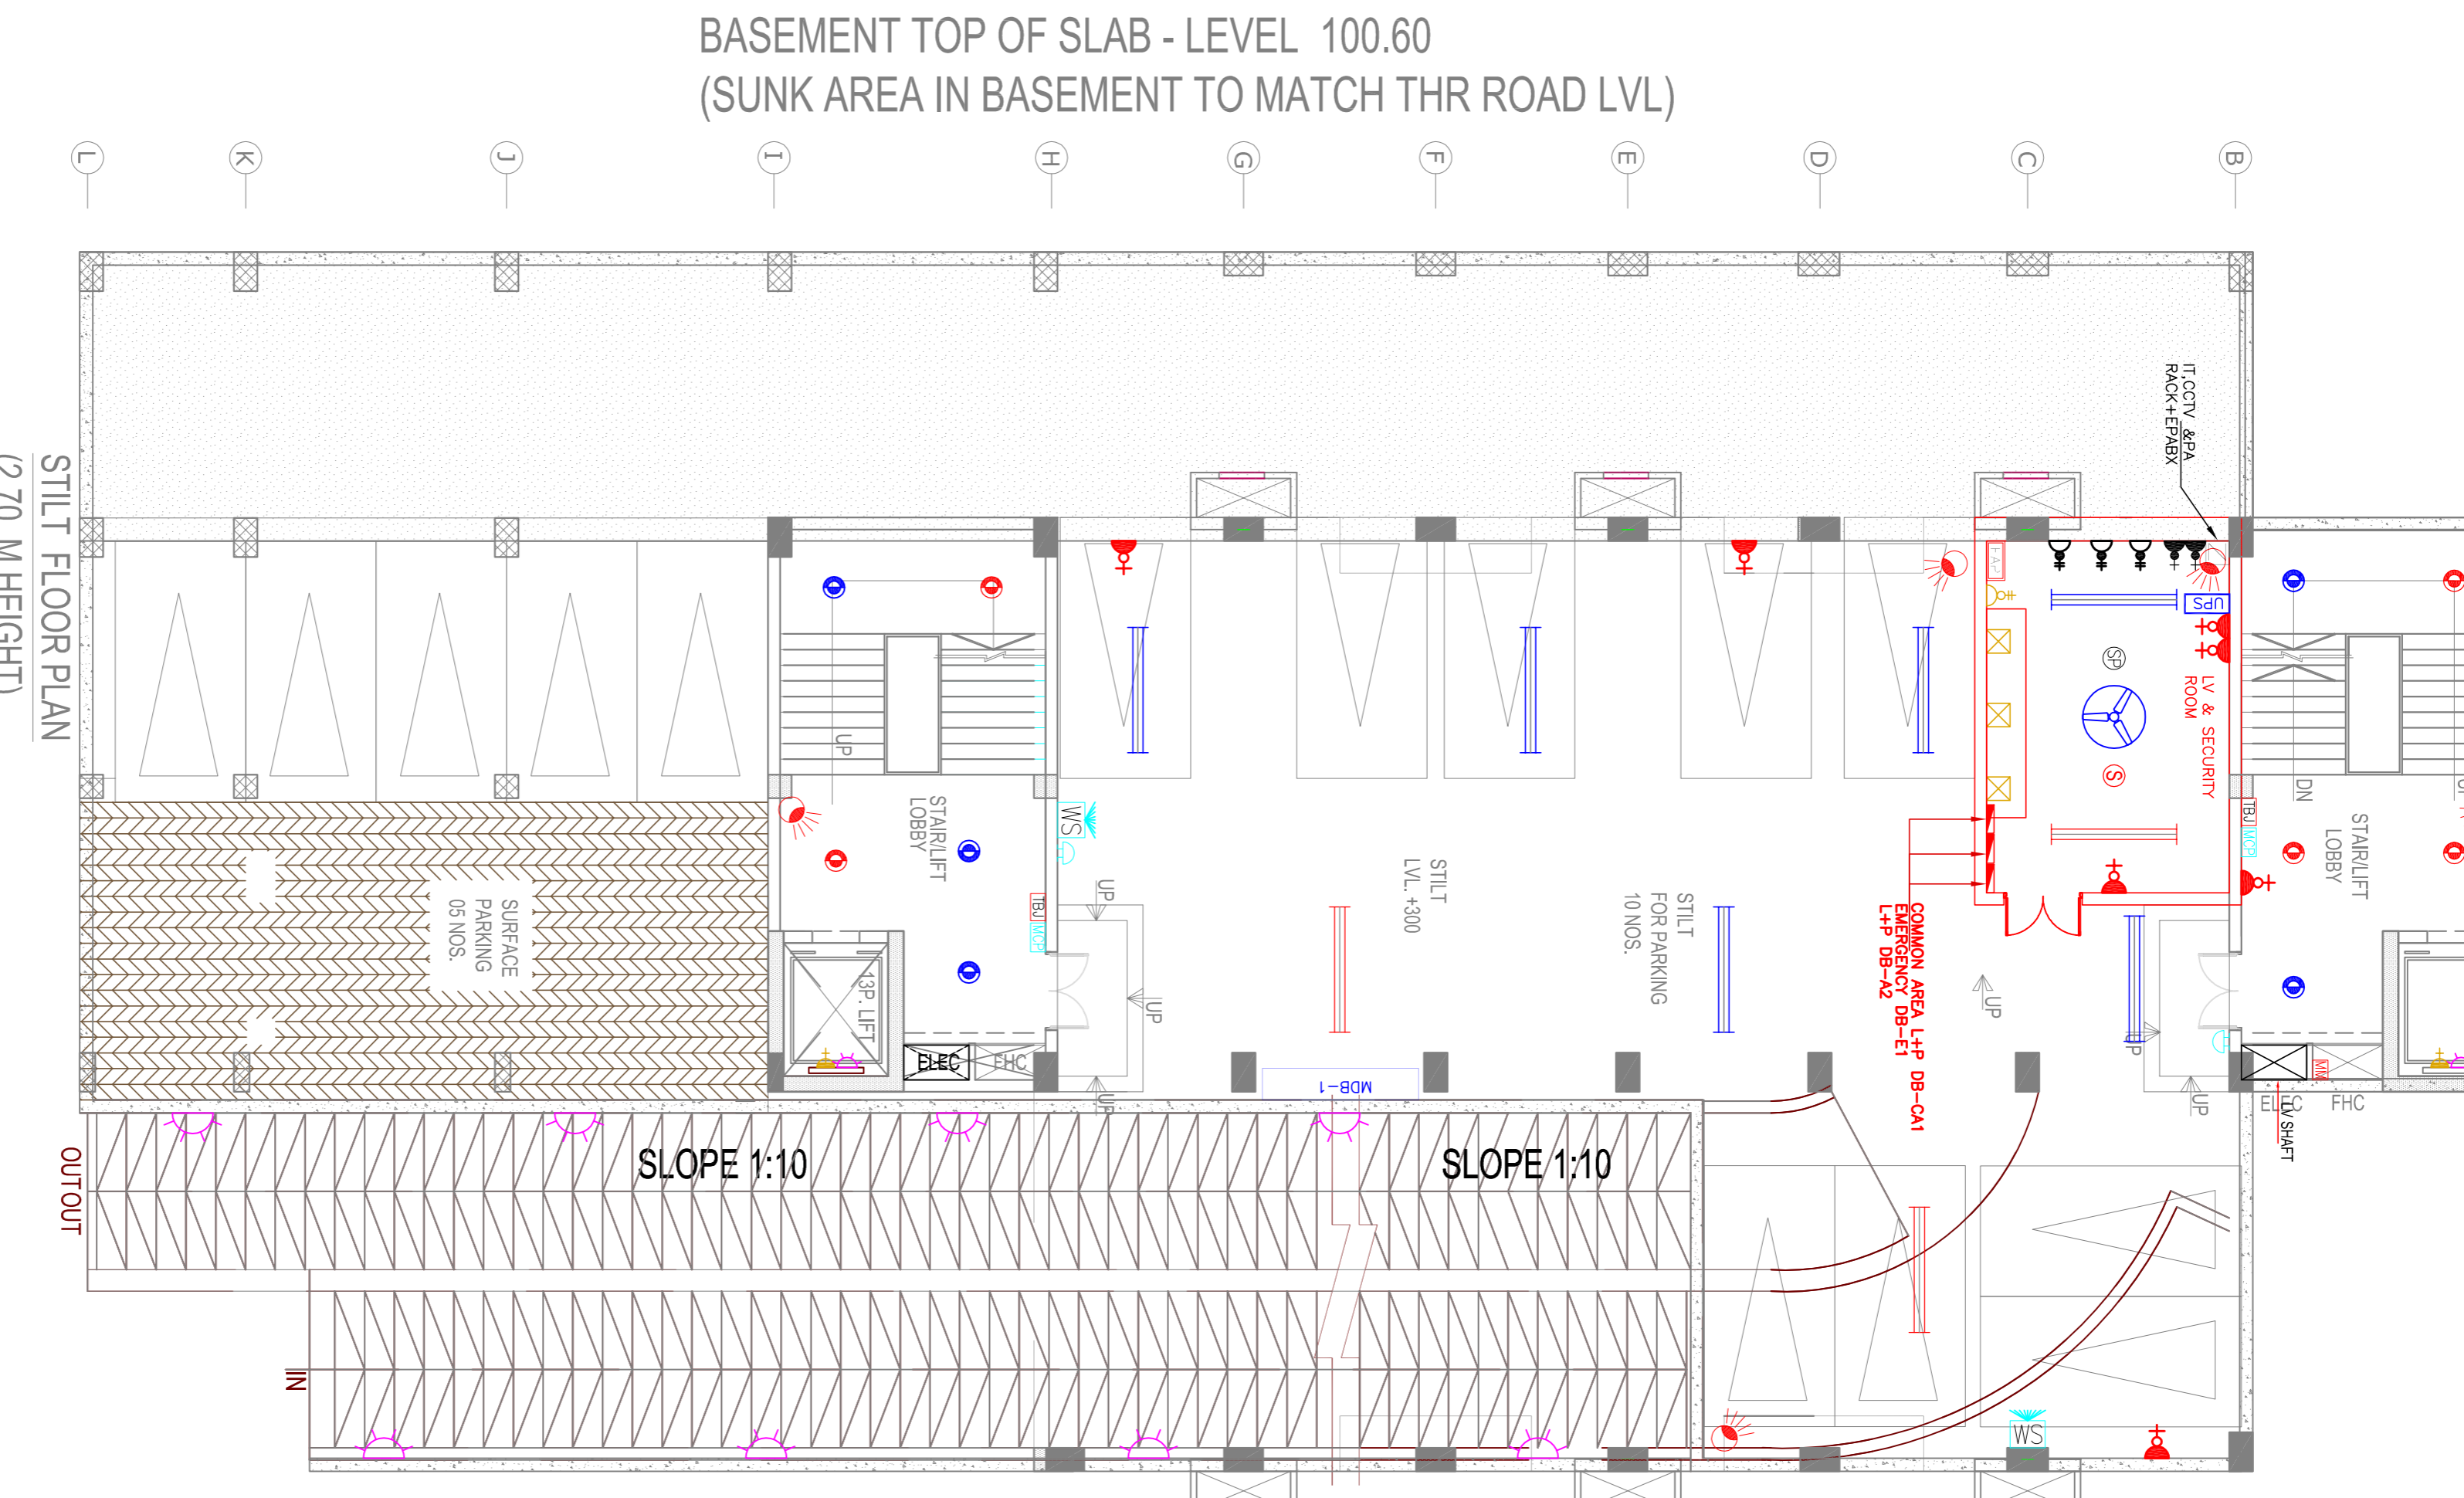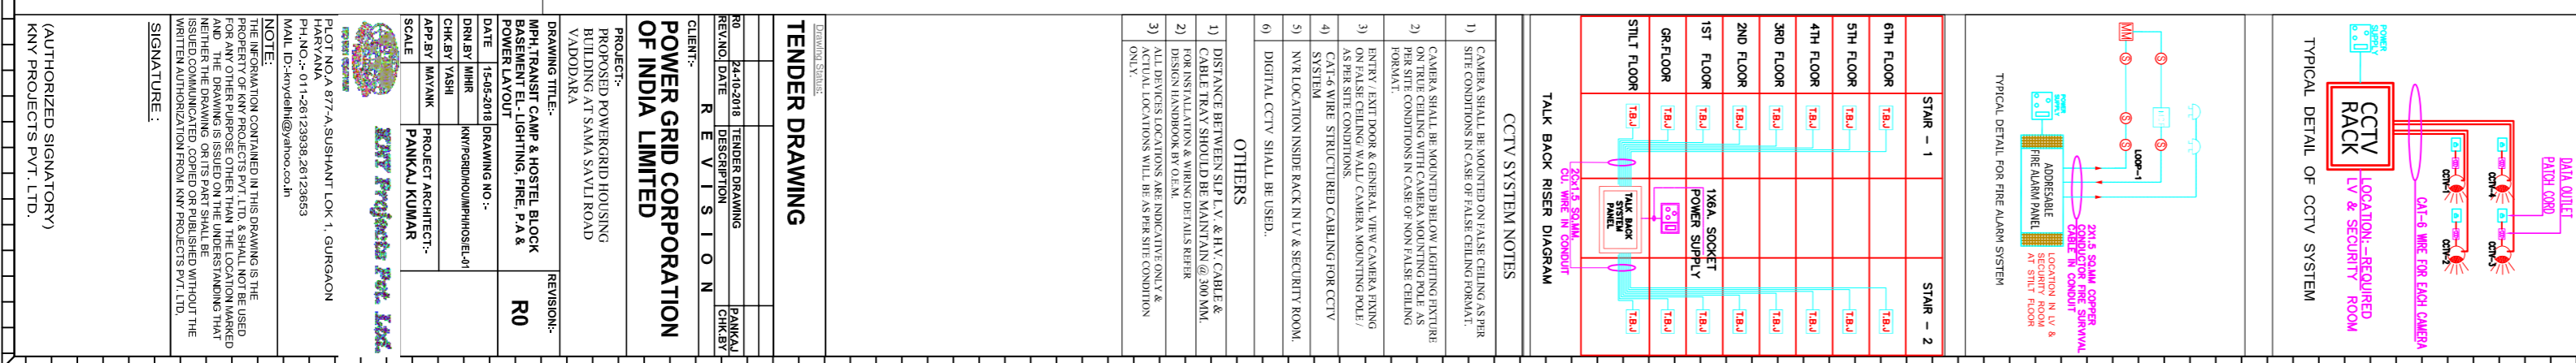

STILT FLOOR PLAN
(2.70 M HEIGHT)

LEGENDS:-

17	BS	BASEMENT TOP OF SLAB - LEVEL 100.60
18	HS	HOSTEL
19	BD	BACK DOOR
20	MD	MONITOR MONITOR

LEGENDS:-

1	BLK	BLACK HEAD LIGHT
2	LD	LED BASED DOWN LIGHT
3	LD	LED BASED DOWN LIGHT
4	LD	LED BASED DOWN LIGHT
5	LD	LED BASED DOWN LIGHT
6	LD	LED BASED DOWN LIGHT
7	LD	LED BASED DOWN LIGHT
8	LD	LED BASED DOWN LIGHT
9	LD	LED BASED DOWN LIGHT
10	LD	LED BASED DOWN LIGHT
11	LD	LED BASED DOWN LIGHT
12	LD	LED BASED DOWN LIGHT
13	LD	LED BASED DOWN LIGHT
14	LD	LED BASED DOWN LIGHT
15	LD	LED BASED DOWN LIGHT
16	LD	LED BASED DOWN LIGHT

POWER GRID CORPORATION OF INDIA LIMITED

TENDER DRAWING

REVISIONS

NO.	DESCRIPTION	DATE
1	ISSUED FOR TENDER	15/08/2024

PROJECT: POWER GRID CORPORATION OF INDIA LIMITED, VANDANVA

DESIGNED BY: POWER GRID CORPORATION OF INDIA LIMITED, VANDANVA

CHECKED BY: POWER GRID CORPORATION OF INDIA LIMITED, VANDANVA

DATE: 15/08/2024

SCALE: AS SHOWN

PRODUCT MANUFACTURER: PANJAB KUMAR

PROJECT MANAGER: POWER GRID CORPORATION OF INDIA LIMITED, VANDANVA

APPROVED BY: POWER GRID CORPORATION OF INDIA LIMITED, VANDANVA

DATE: 15/08/2024

PROJECT: POWER GRID CORPORATION OF INDIA LIMITED, VANDANVA

DESIGNED BY: POWER GRID CORPORATION OF INDIA LIMITED, VANDANVA

CHECKED BY: POWER GRID CORPORATION OF INDIA LIMITED, VANDANVA

DATE: 15/08/2024

SCALE: AS SHOWN

PRODUCT MANUFACTURER: PANJAB KUMAR

PROJECT MANAGER: POWER GRID CORPORATION OF INDIA LIMITED, VANDANVA

APPROVED BY: POWER GRID CORPORATION OF INDIA LIMITED, VANDANVA

DATE: 15/08/2024

