
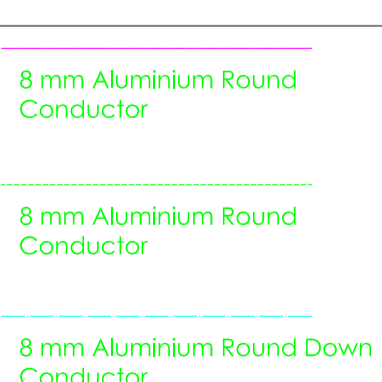
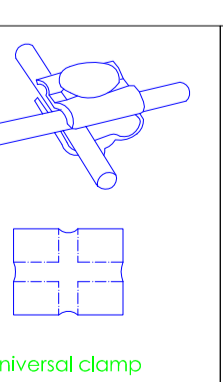
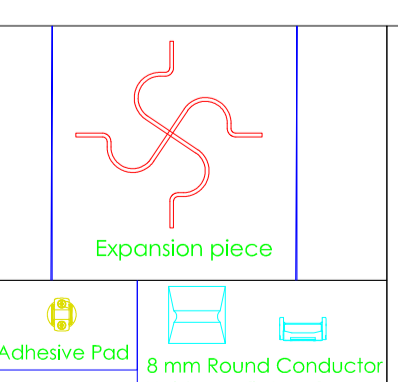
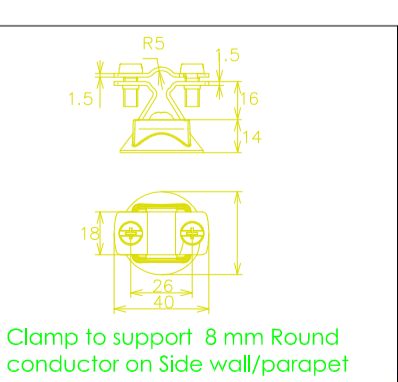


Drawing Station:			
<b>TENDER DRAWING</b>			
REV. NO.	DATE	DESCRIPTION	CHK. BY
R0	24-10-2018	TENDER DRAWING	PANKAJ
<b>REVISION</b>			
CLIENT:-			
<b>POWER GRID CORPORATION OF INDIA LIMITED</b>			
PROJECT:-			
PROPOSED POWERGRID HOUSING BUILDING AT SAMA SAVLI ROAD VADODARA			
DRAWING TITLE:-			REVISION:-
<b>MPH TRANSIT CAMP &amp; HOSTEL BLOCK TERRACE FLOOR LIGHTNING ARRESTER LAYOUT</b>			<b>R0</b>
DATE	15-05-2018	DRAWING NO. :-	
DRN. BY	MIHR	KNY:PGRDH0UMPHH0S145	
CHK. BY	YASHI		
APP. BY	MAYANK	PROJECT ARCHITECT:- PANKAJ KUMAR	
SCALE			

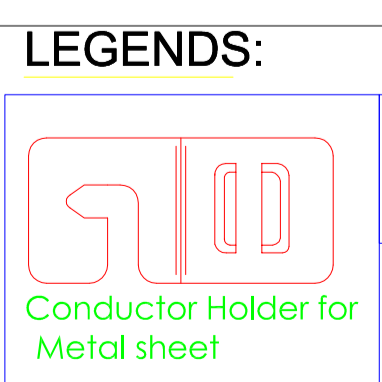



**KNY Projects Pvt. Ltd.**

PLOT NO. A 877-A, SUSHANT LOK 1, GURGAON HARYANA  
 PH. NO. :- 011-26123938, 26123653  
 MAIL ID:- knydeh@yahoo.co.in

**NOTE:**  
 THE INFORMATION CONTAINED IN THIS DRAWING IS THE PROPERTY OF KNY PROJECTS PVT. LTD. & SHALL NOT BE USED FOR ANY OTHER PURPOSE OTHER THAN THE LOCATION MARKED AND THE DRAWING IS ISSUED ON THE UNDERSTANDING THAT NEITHER THE DRAWING OR ITS PART SHALL BE ISSUED, COMMUNICATED, COPIED OR PUBLISHED WITHOUT THE WRITTEN AUTHORIZATION FROM KNY PROJECTS PVT. LTD.

SIGNATURE : \_\_\_\_\_

(AUTHORIZED SIGNATORY)  
 KNY PROJECTS PVT. LTD.

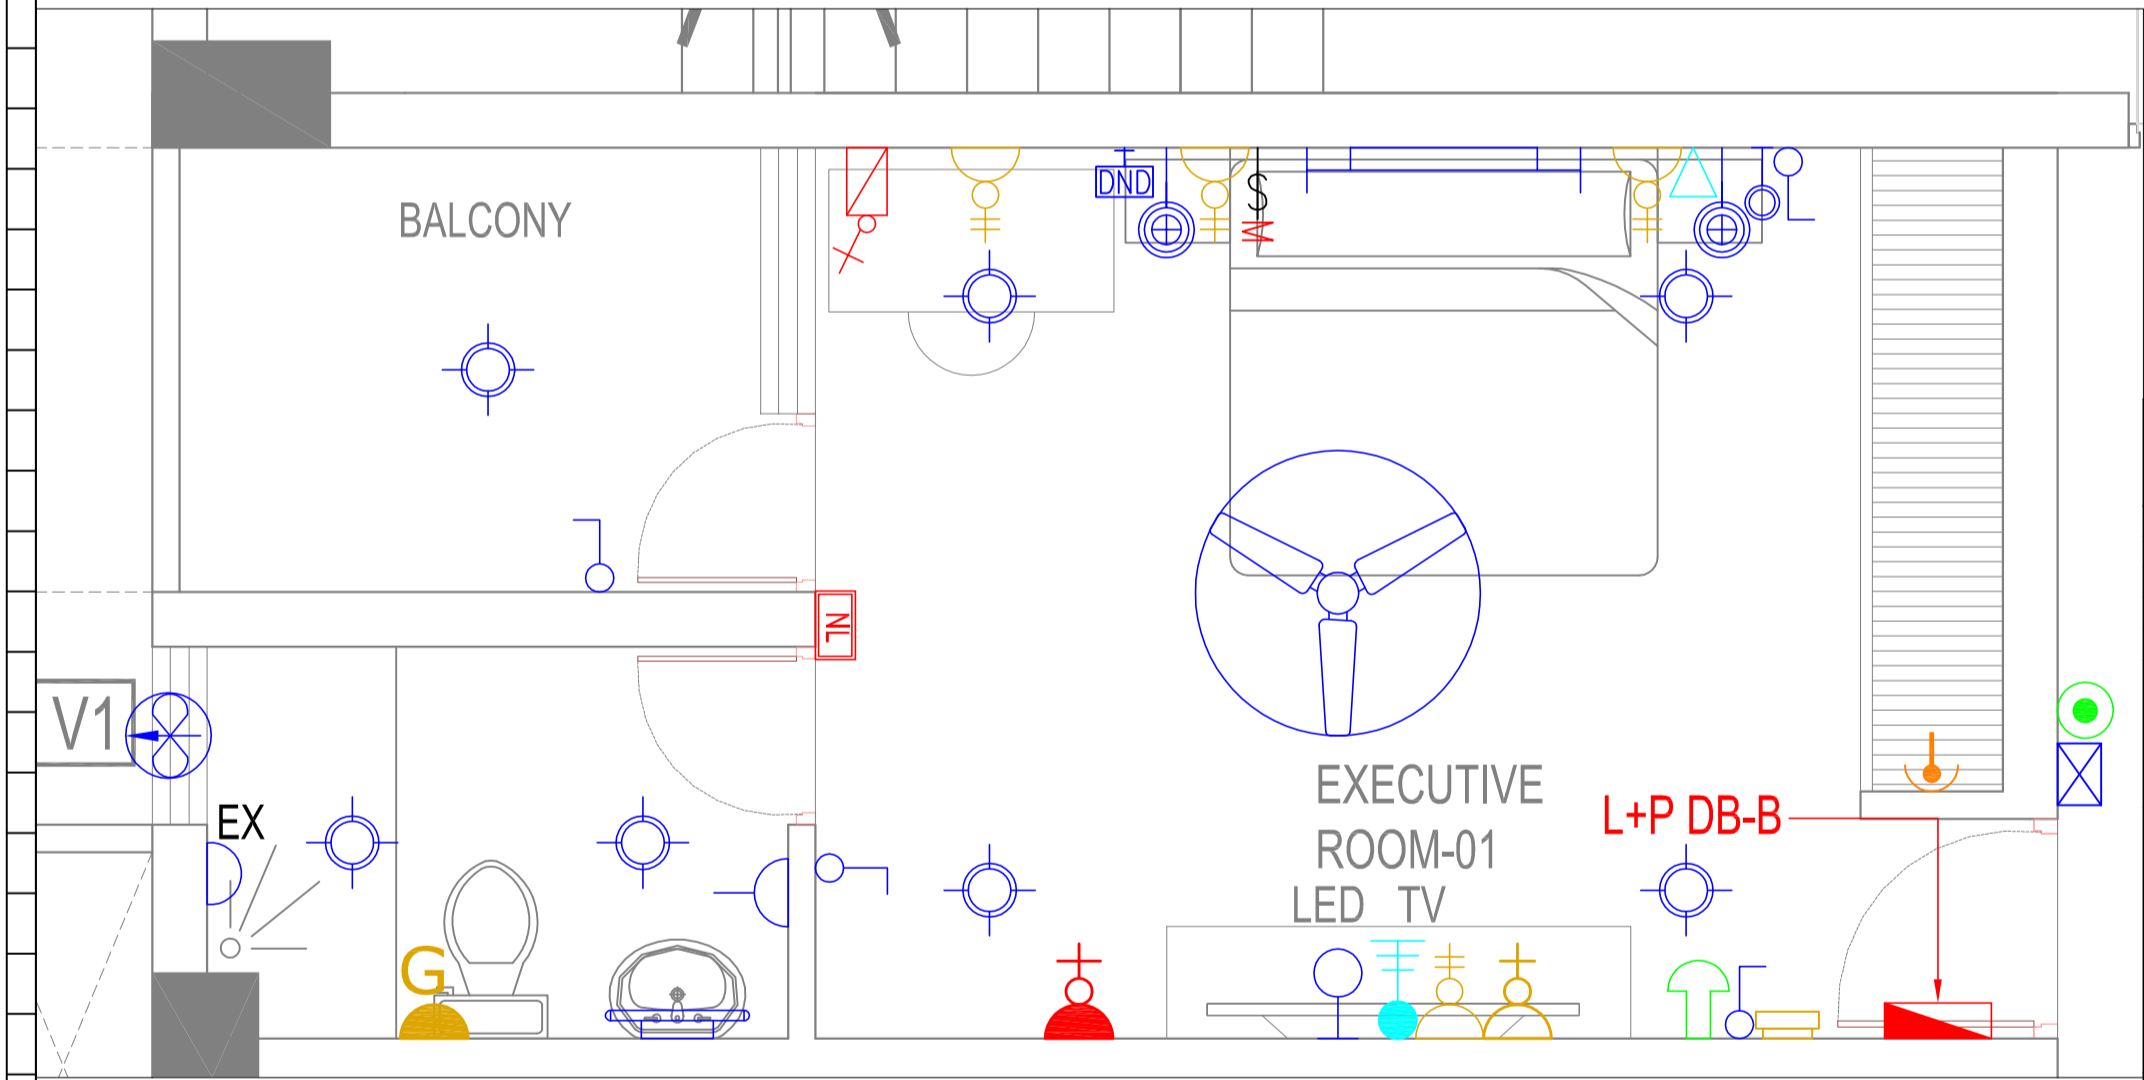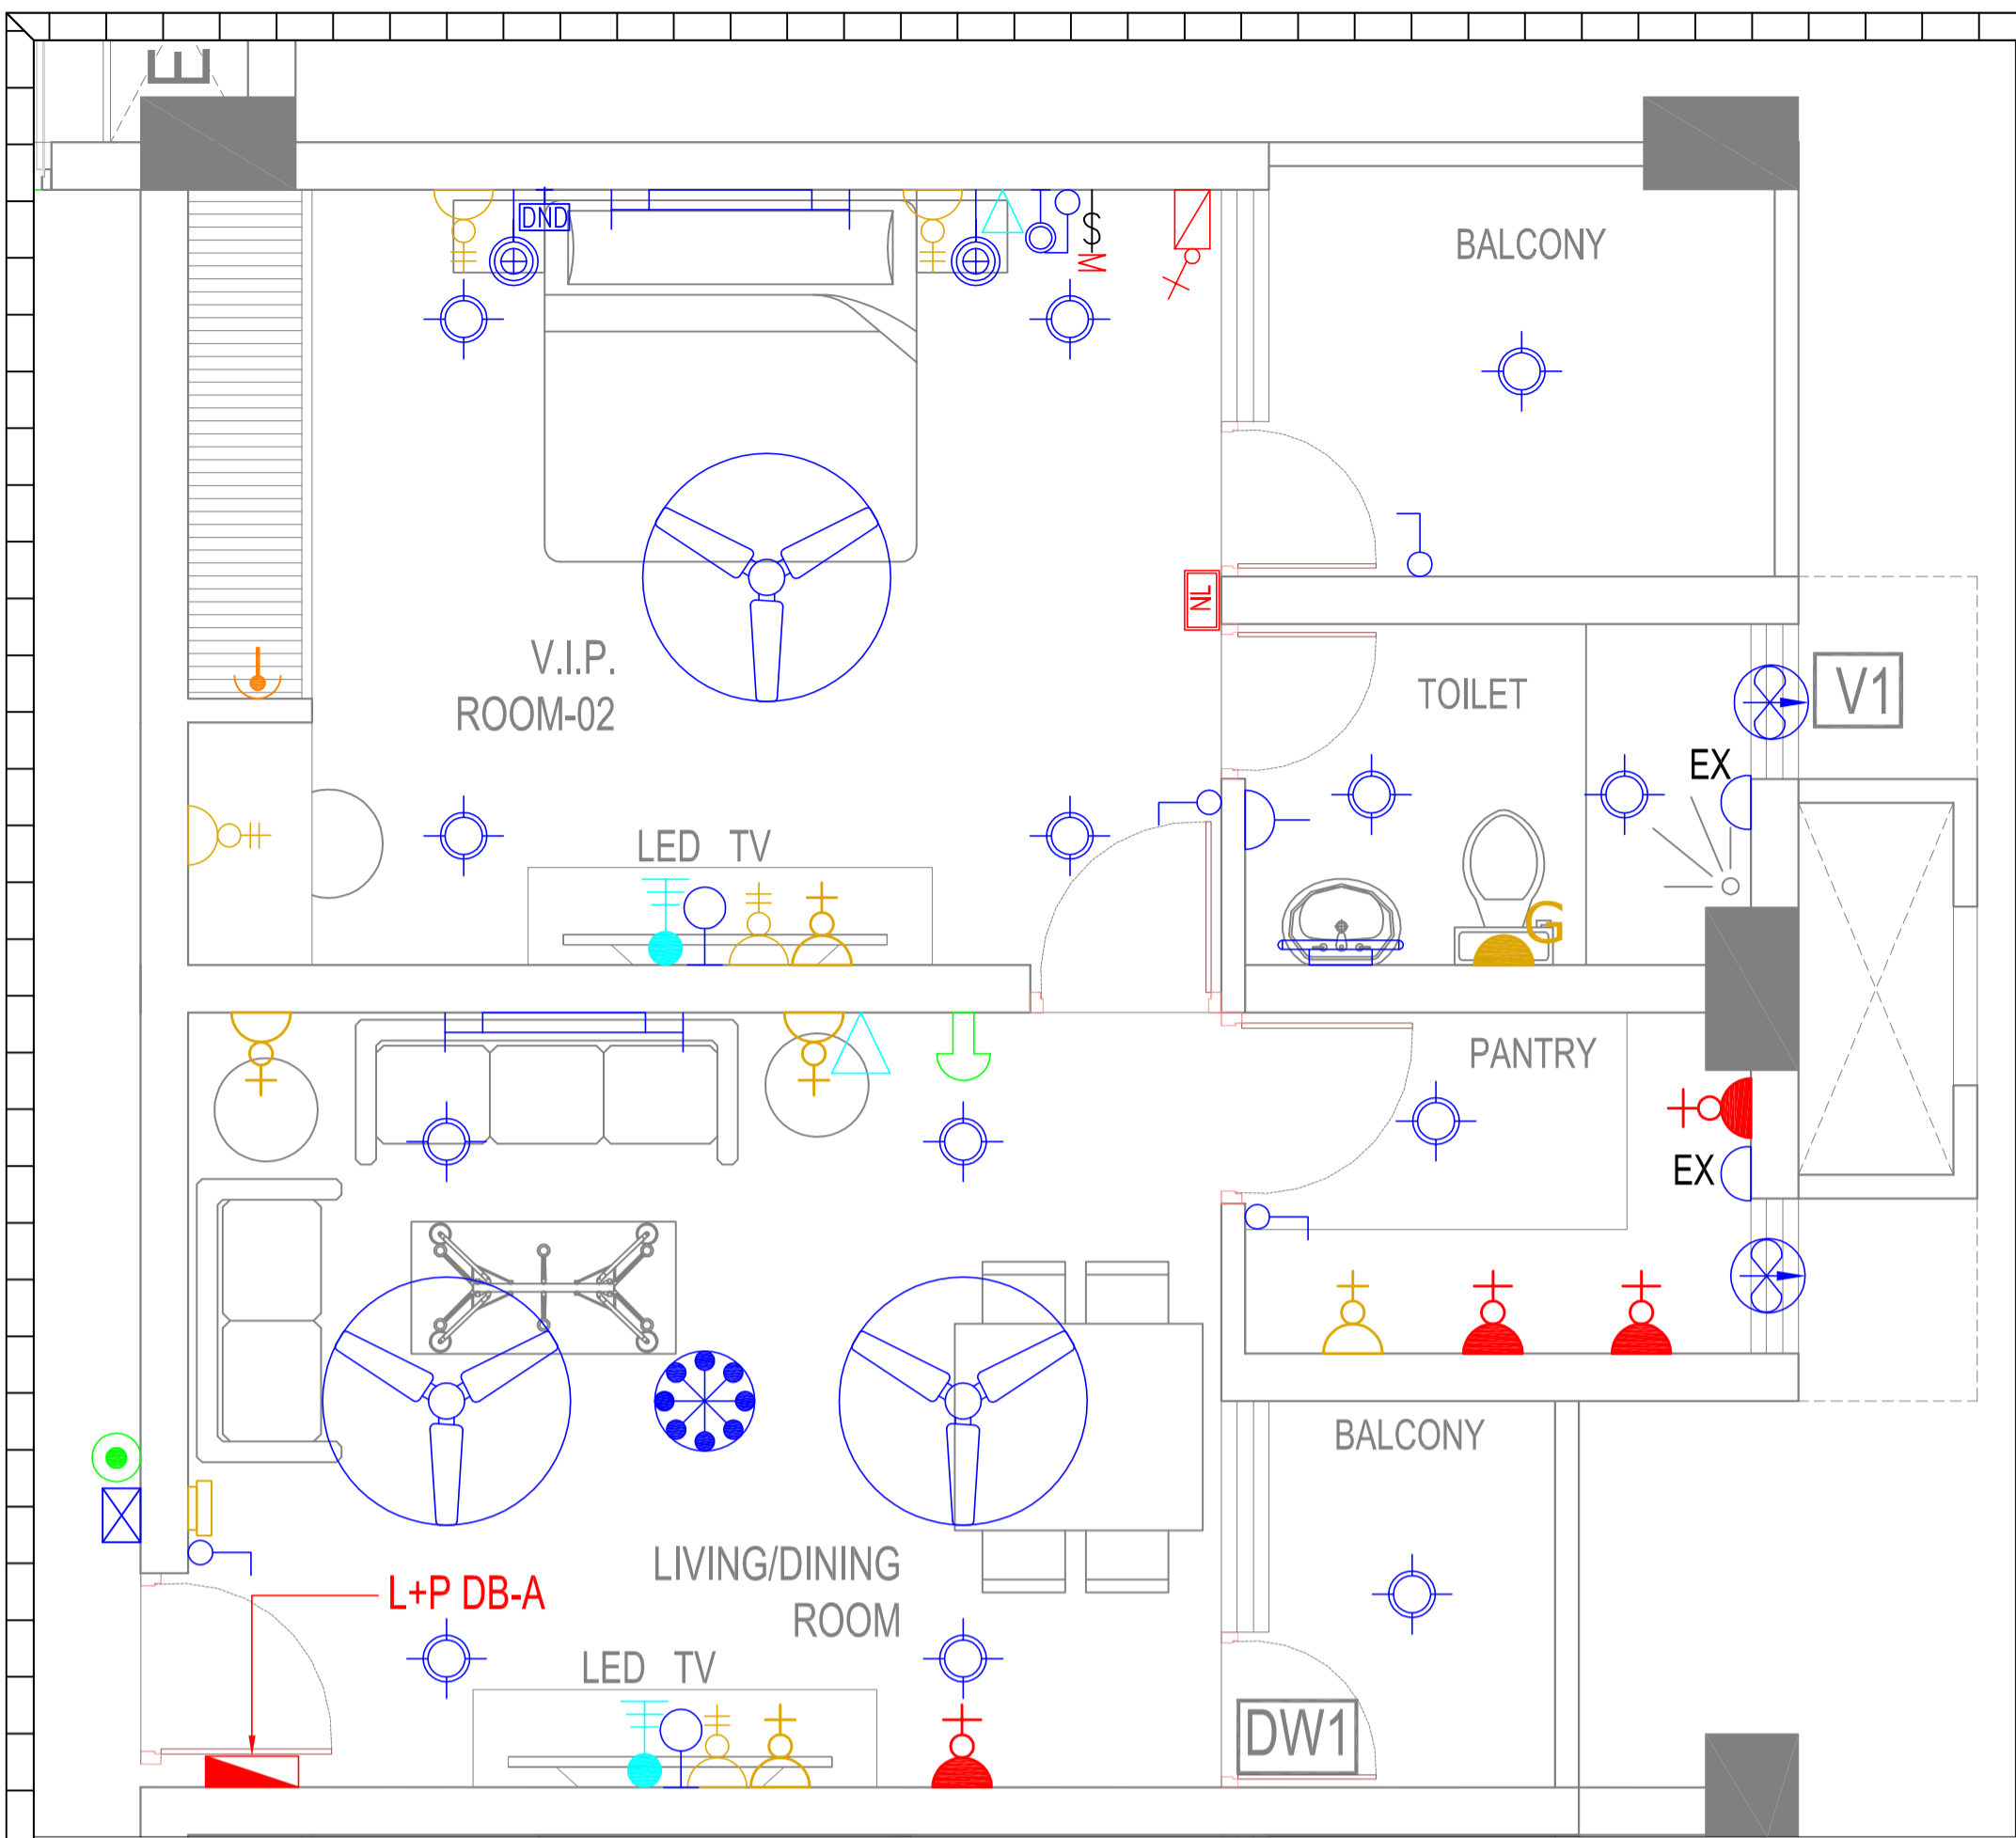

LEGENDS:-

S.NO	SYMBOL	DESCRIPTION
1		LED DOWNLIGHTER
2		1x36W WALL LIGHT
3		BRACKET LIGHT
4		CEILING FAN
5		EXHAUST FAN
6		FAN REGULATOR
7		CEILING ROSE
8		MIRROR LIGHT
9		BELL PUSH
10		BELL BUZZER
11		SWITCH BOARD
12		6A POWER OUTLET FOR SHAVER POINT
13		6A POWER OUTLET (RAW) WITH 1x6A SWITCH
14		16A POWER OUTLET (RAW) WITH 1x16A SWITCH

15		25A SOCKET OUTLET FOR AC INDOOR UNIT
16		T.V. OUTLET
17		TELEPHONE OUTLET
18		DISTRIBUTION BOARD
19		KEY TAG
20		DND & MMR SWITCH
21		DND & MMR LIGHT
22		MICRO SWITCH
23		MASTER SWITCH
24		NIGHT LIGHT
25		BRACKET LIGHT

Drawing Status:  
**TENDER DRAWING**

REV.NO.	DATE	TENDER DRAWING DESCRIPTION	PANKAJ CHK.BY
R0	24-10-2018	TENDER DRAWING	PANKAJ

CLIENT:-  
**POWER GRID CORPORATION OF INDIA LIMITED**

PROJECT:-  
PROPOSED POWERGRID HOUSING BUILDING AT SAMA SAVLI ROAD VADODARA

DRAWING TITLE:-  
MPH,TRANSIT CAMP & HOSTEL BLOCK ELECTRICAL LAYOUT  
VIP ROOM & EXECUTIVE ROOM DETAIL

DATE	15-05-2018	DRAWING NO :-	REVISION:-
DRN.BY	MIHIR	KNY/PGRID/HOU/MPH/HOS/EL-16	R0
CHK.BY	YASHI		
APP.BY	MAYANK	PROJECT ARCHITECT:- PANKAJ KUMAR	

**KNY Projects Pvt. Ltd.**  
ISO 9001 COMPANY

PLOT NO. A 877-A, SUSHANT LOK 1, GURGAON HARYANA  
PH. NO. :- 011-26123938, 26123653  
MAIL ID :- knydelhi@yahoo.co.in

NOTE:  
THE INFORMATION CONTAINED IN THIS DRAWING IS THE PROPERTY OF KNY PROJECTS PVT. LTD. & SHALL NOT BE USED FOR ANY OTHER PURPOSE OTHER THAN THE LOCATION MARKED AND THE DRAWING IS ISSUED ON THE UNDERSTANDING THAT NEITHER THE DRAWING OR ITS PART SHALL BE ISSUED, COMMUNICATED, COPIED OR PUBLISHED WITHOUT THE WRITTEN AUTHORIZATION FROM KNY PROJECTS PVT. LTD.

SIGNATURE :  
  
(AUTHORIZED SIGNATORY)  
KNY PROJECTS PVT. LTD.